

SHIY  ARCH

PROJECT:
IMMIGRATION OFFICE INTERIOR
STAR CLOUD BUILDING
CLIENT:
MALDIVES IMMIGRATION












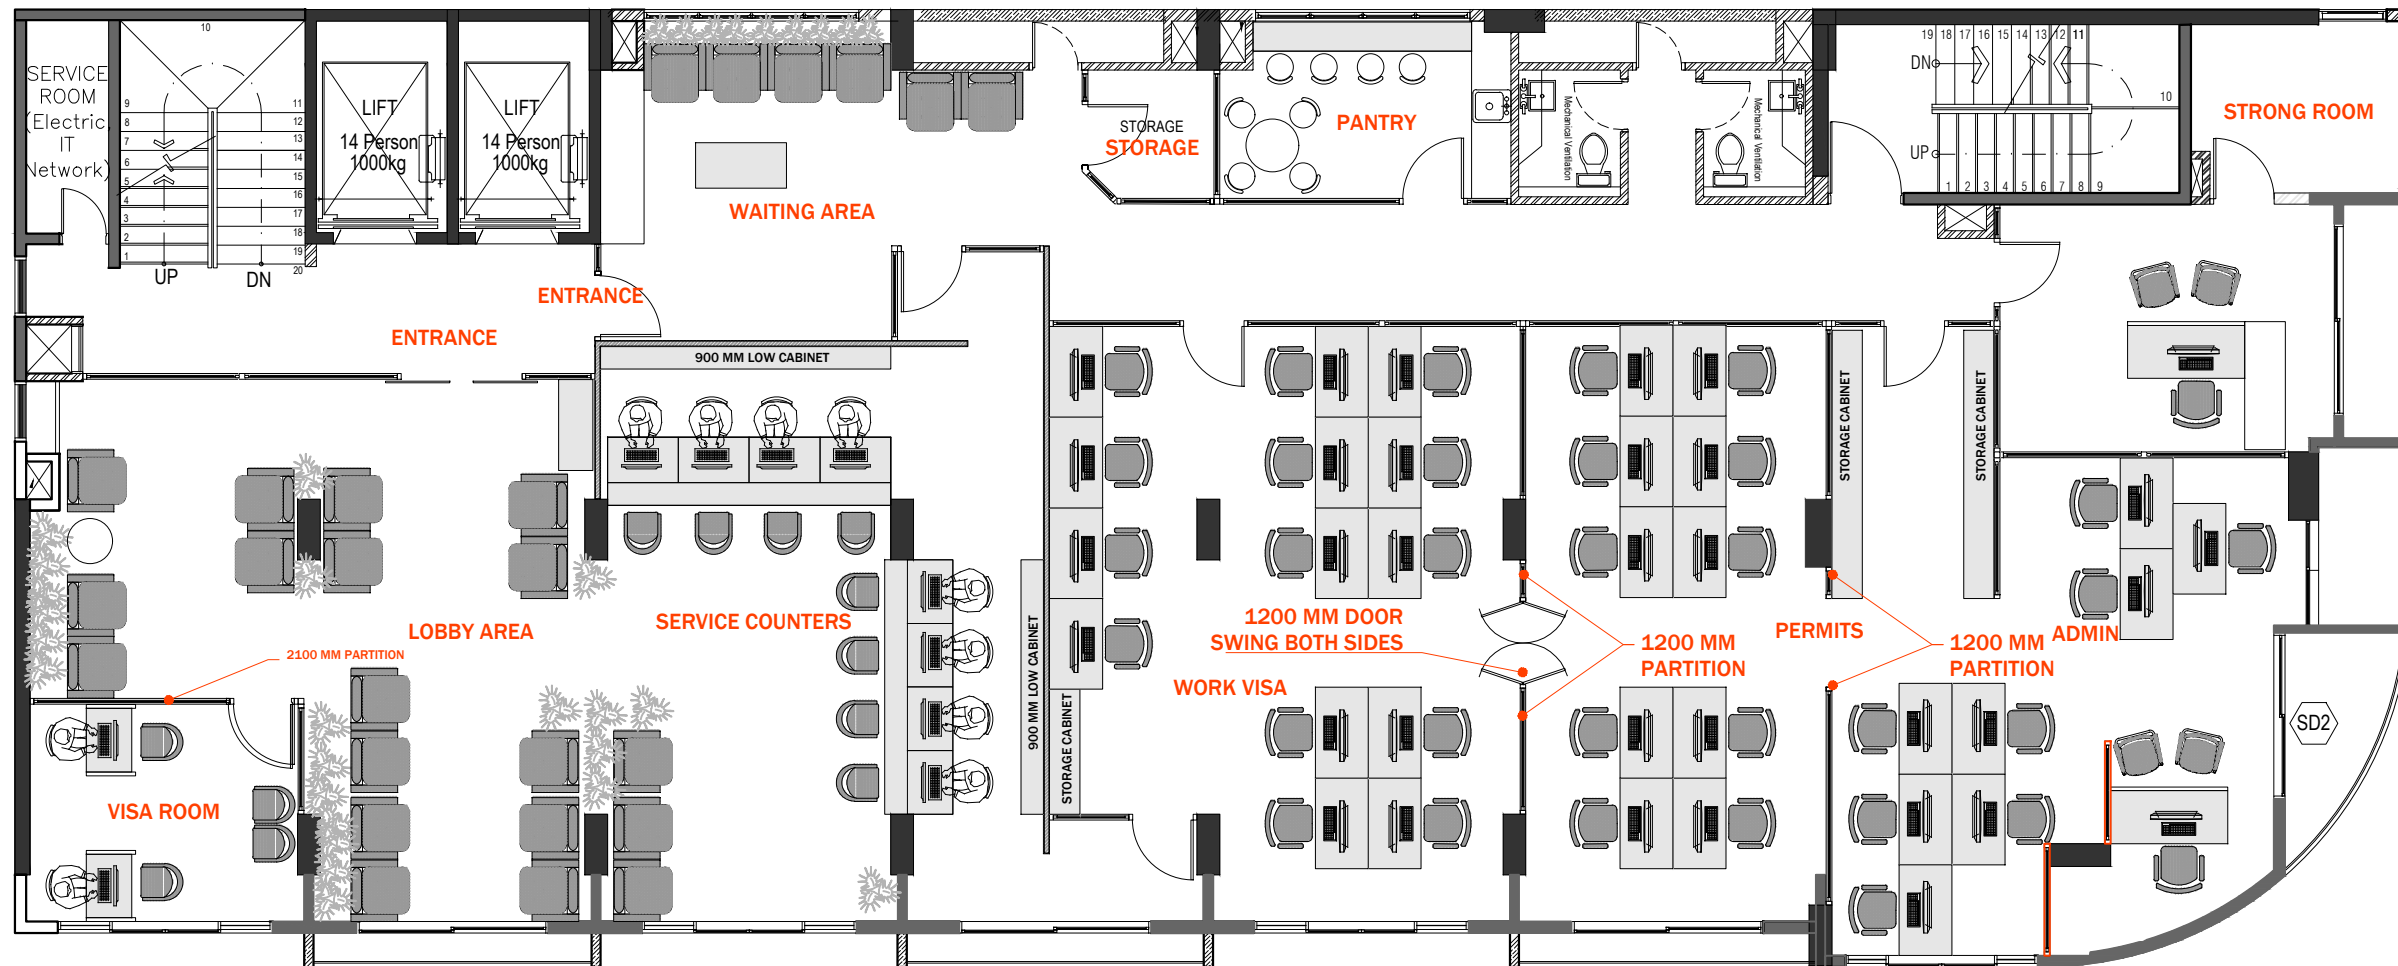

8TH FLOOR PLAN_OFFICES

SCALE 1:100



SHIYARCH

No.	Revision	Checked By	Date

Project Title:

IMMIGRATION OFFICE
(AT STAR CLOUD BUILDING)

Client:


MALDIVES IMMIGRATION

INTERIOR DESIGN

Drawing Title:
SITE PLAN

Architect:	Interior Designer:
SHIYA	
Drawn By:	Checked By:
A3	
Date:	Scale:
FEBRUARY 2021	AS GIVEN
Drawing No:	D-01 /01

Copyright: The concept and design in this drawing are the properties of shiyarch. unauthorized use of any kind or copying of whole or part of this drawing, concept or design or use on projects or sites other than specified on this drawing is prohibited and apply as terms and conditions under which the client is entitled to use the concept or design in this drawing.

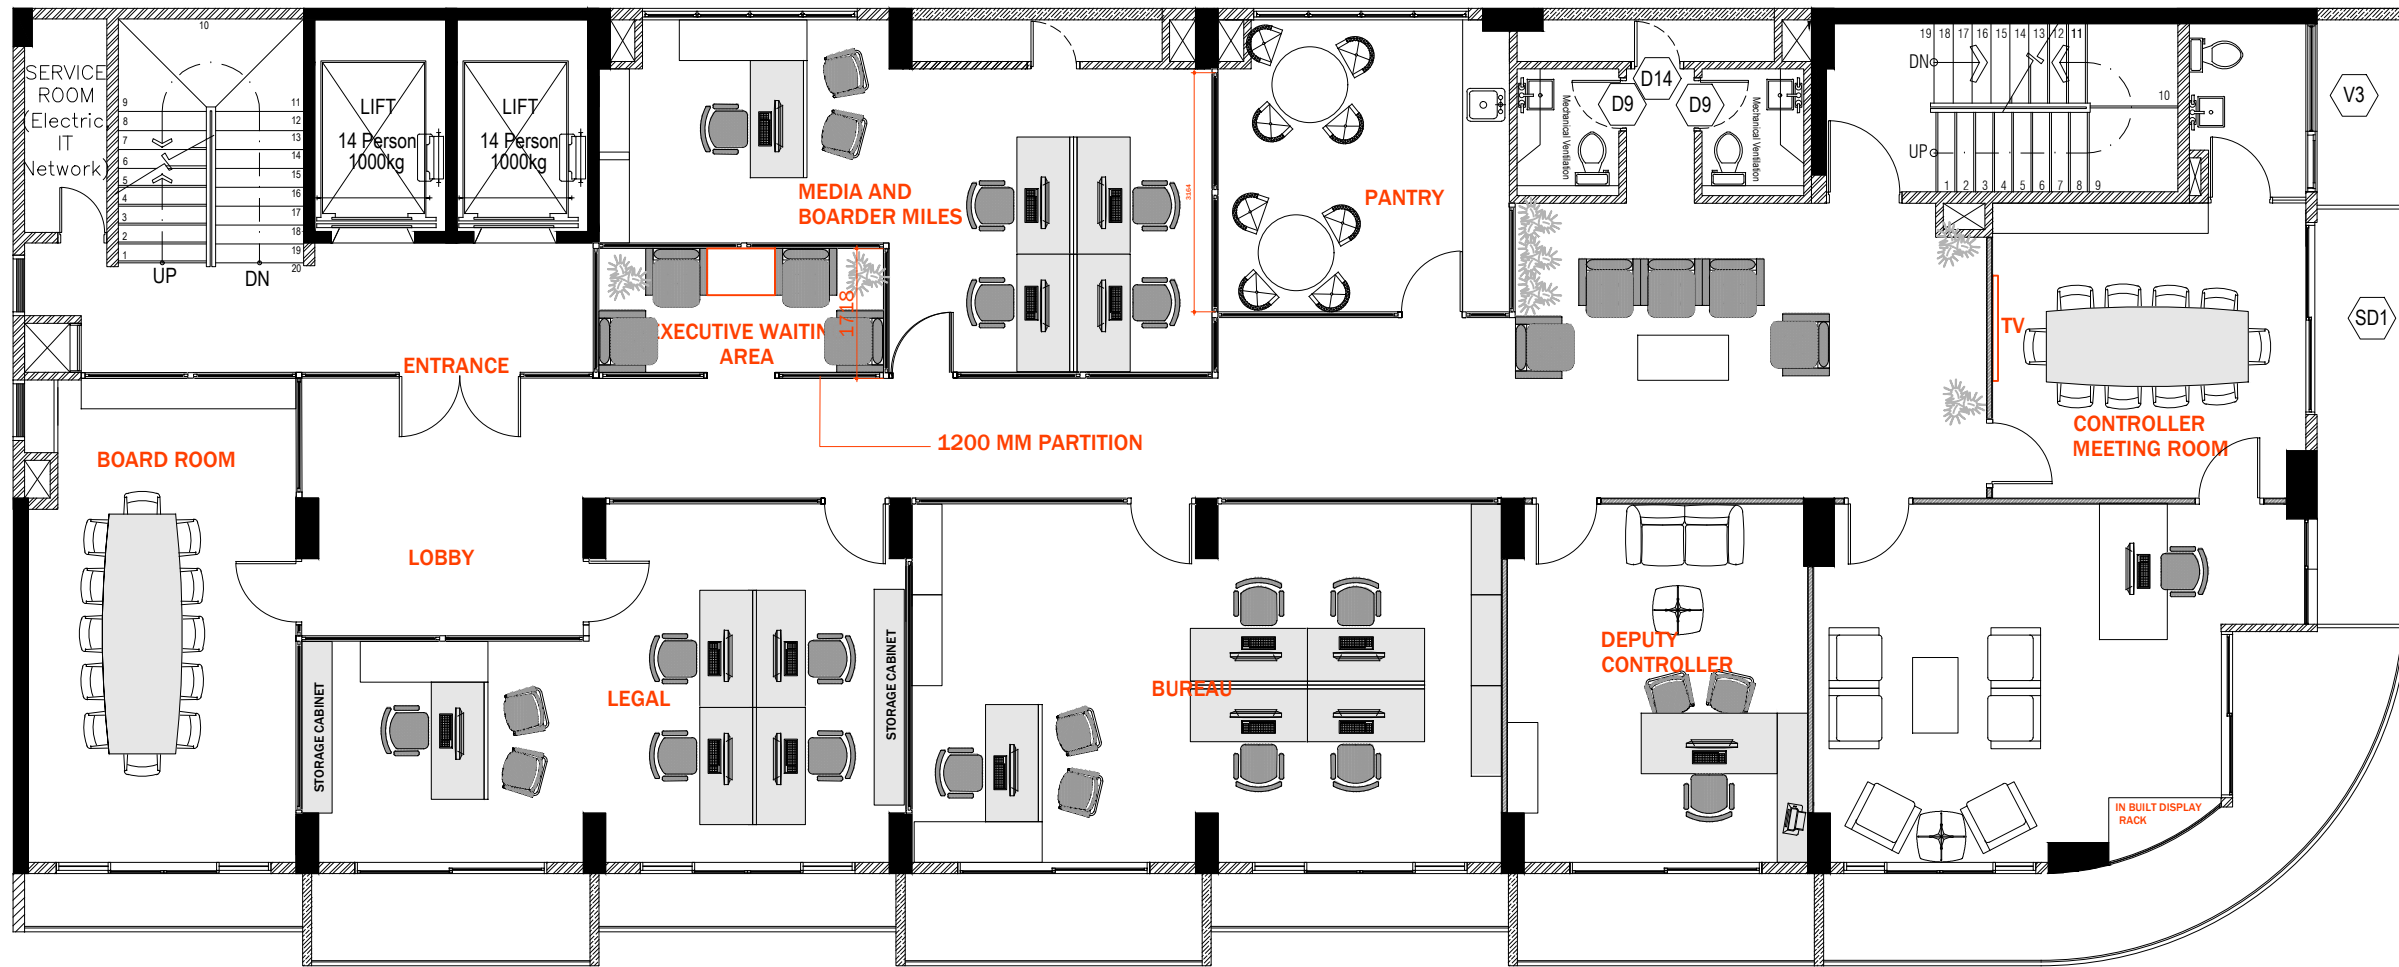

9TH FLOOR PLAN_OFFICES

SCALE 1:100



SHIYARCH

No.	Revision	Checked By	Date

Project Title:

IMMIGRATION OFFICE
(AT STAR CLOUD BUILDING)


Client:
MALDIVES IMMIGRATION

INTERIOR DESIGN

Drawing Title:
SITE PLAN

Architect: SHIYA	Interior Designer: -
Drawn By: SHIYA	Checked By: -
Paper: A3	Project No: -
Date: FEBRUARY 2021	Scale: AS GIVEN
Drawing No: D-01 /01	

Copyright: The concept and design in this drawing are the properties of shiyarch. unauthorized use of any kind or copying of whole or part of this drawing, concept or design or use on projects or sites other than specified on this drawing is prohibited and apply as terms and conditions under which the client is entitled to use the concept or design in this drawing.

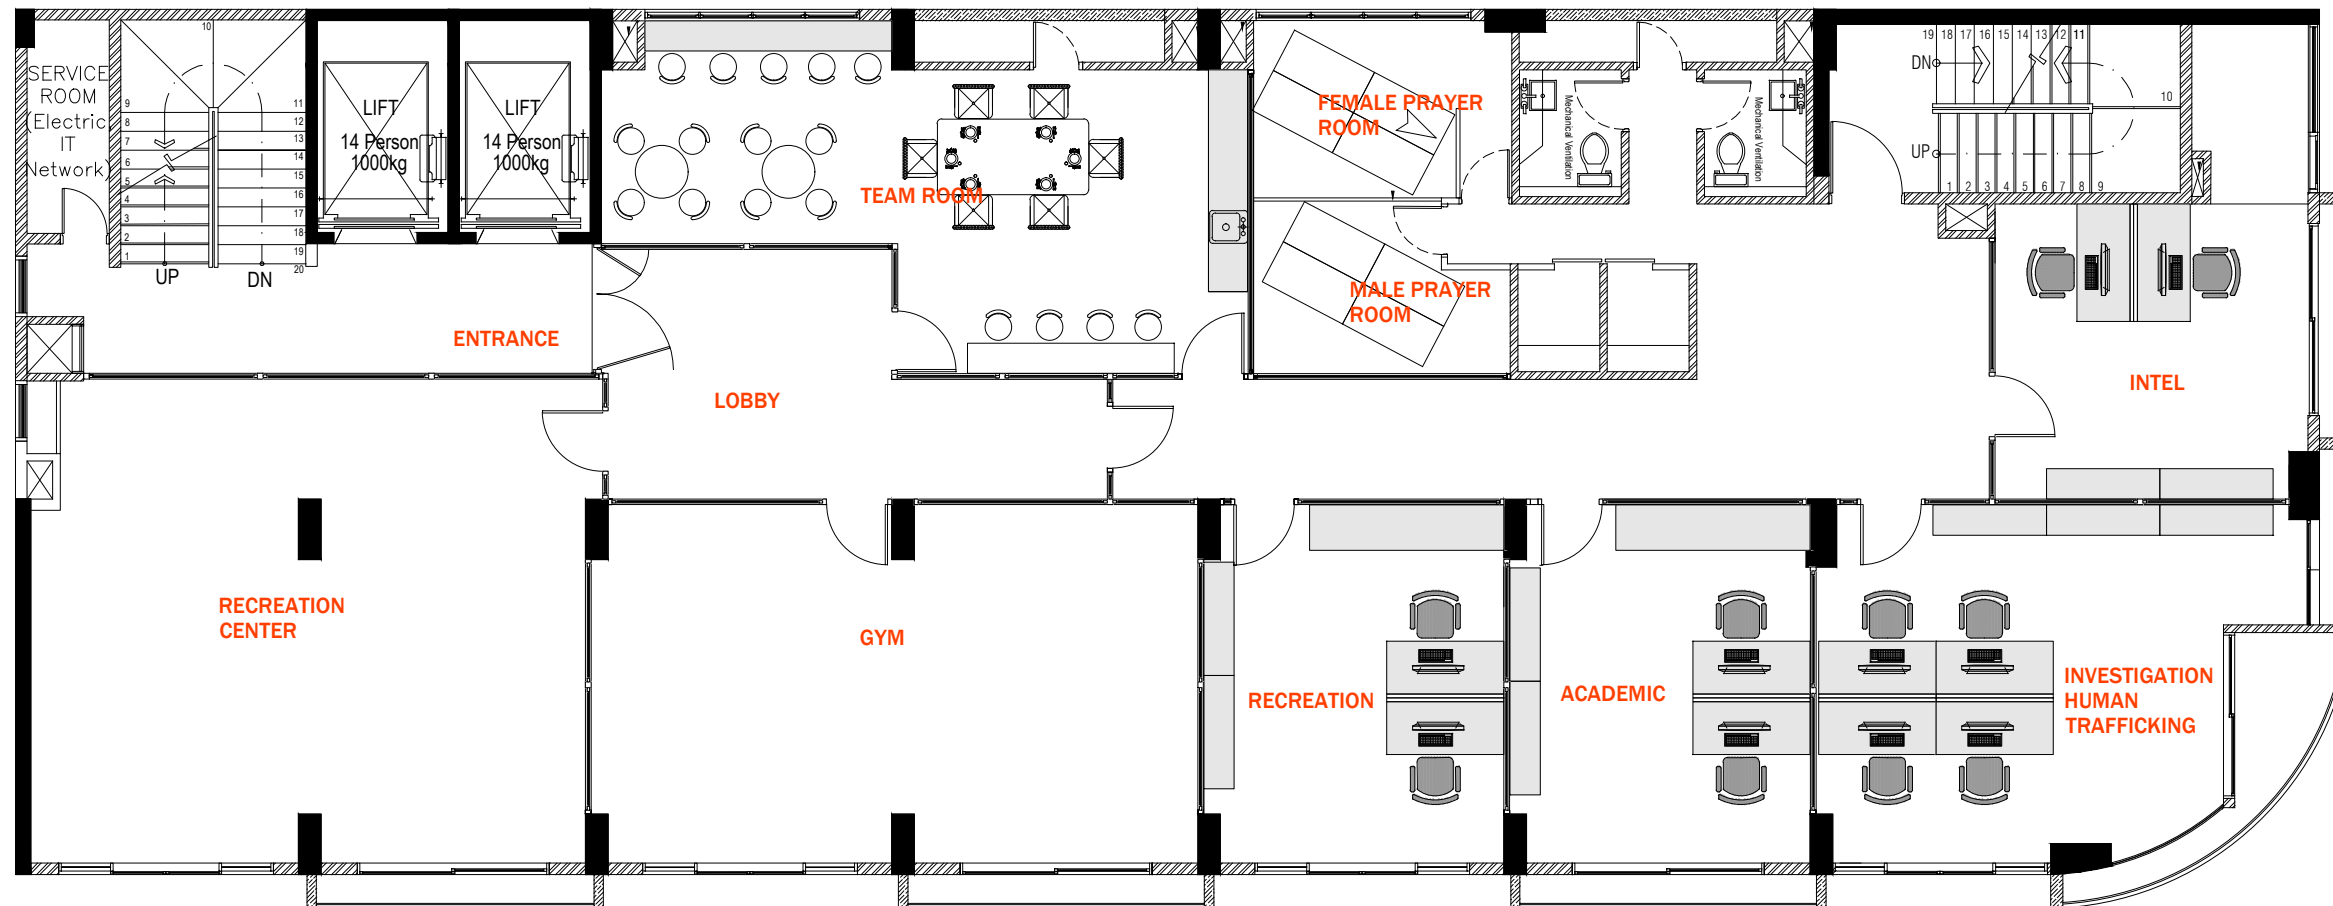

10TH FLOOR PLAN_OFFICES

SCALE 1:100



SHIYARCH

No.	Revision	Checked By	Date

Project Title:

IMMIGRATION OFFICE
(AT STAR CLOUD BUILDING)

Client:


MALDIVES IMMIGRATION

INTERIOR DESIGN

Drawing Title:
SITE PLAN

Architect: -	Interior Designer: -
Drawn By: SHIYA	Checked By: -
Paper: A3	Project No: -
Date: FEBRUARY 2021	Scale: AS GIVEN
Drawing No: D-01 /01	

Copyright: The concept and design in this drawing are the properties of shiyarch. unauthorized use of any kind or copying of whole or part of this drawing, concept or design or use on projects or sites other than specified on this drawing is prohibited and apply as terms and conditions under which the client is entitled to use the concept or design in this drawing.

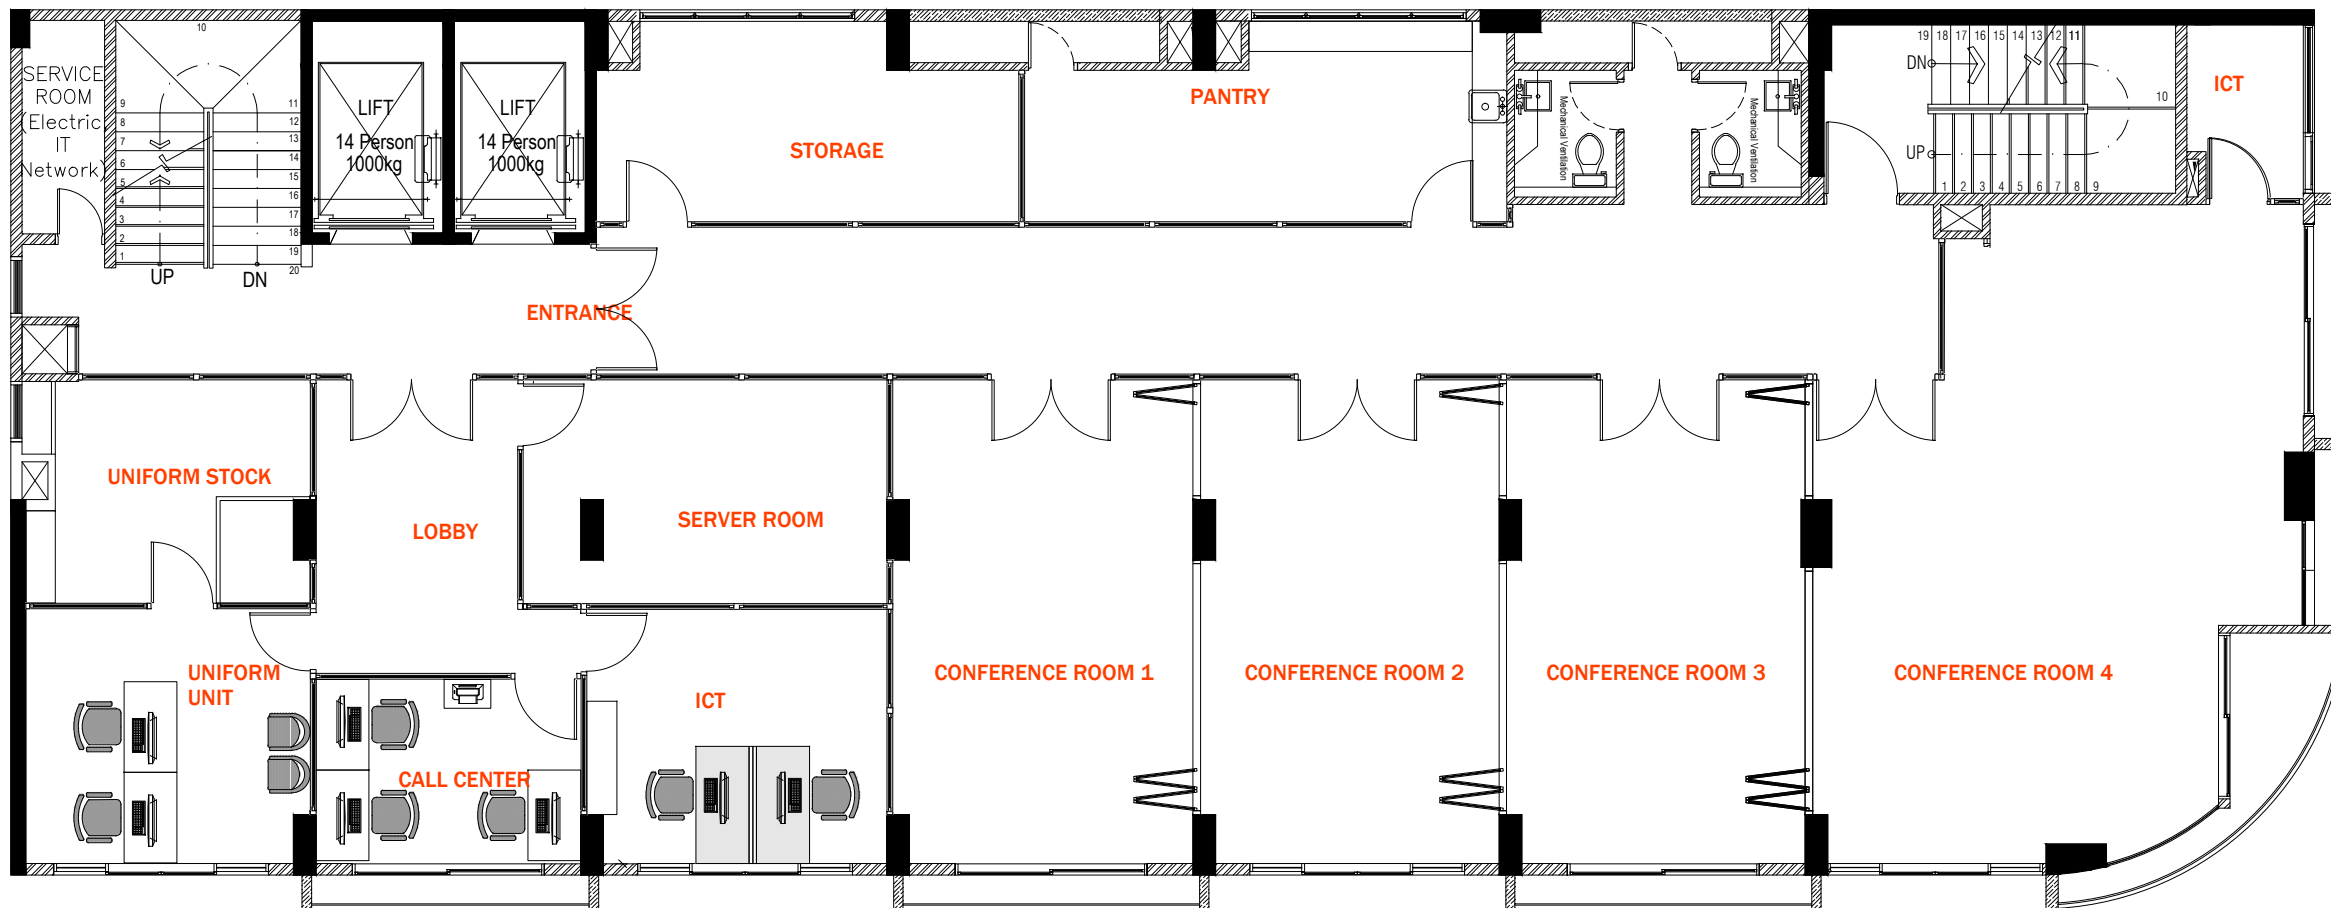

11TH FLOOR PLAN_OFFICES

SCALE 1:100



SHIYARCH

No.	Revision	Checked By	Date

Project Title:

IMMIGRATION OFFICE
(AT STAR CLOUD BUILDING)

Client:


MALDIVES IMMIGRATION

INTERIOR DESIGN

Drawing Title:
SITE PLAN

Architect: -	Interior Designer: -
Drawn By: SHIYA	Checked By: -
Paper: A3	Project No: -
Date: FEBRUARY 2021	Scale: AS GIVEN
Drawing No: D-01 /01	

Copyright: The concept and design in this drawing are the properties of shiyarch. unauthorized use of any kind or copying of whole or part of this drawing, concept or design or use on projects or sites other than specified on this drawing is prohibited and apply as terms and conditions under which the client is entitled to use the concept or design in this drawing.

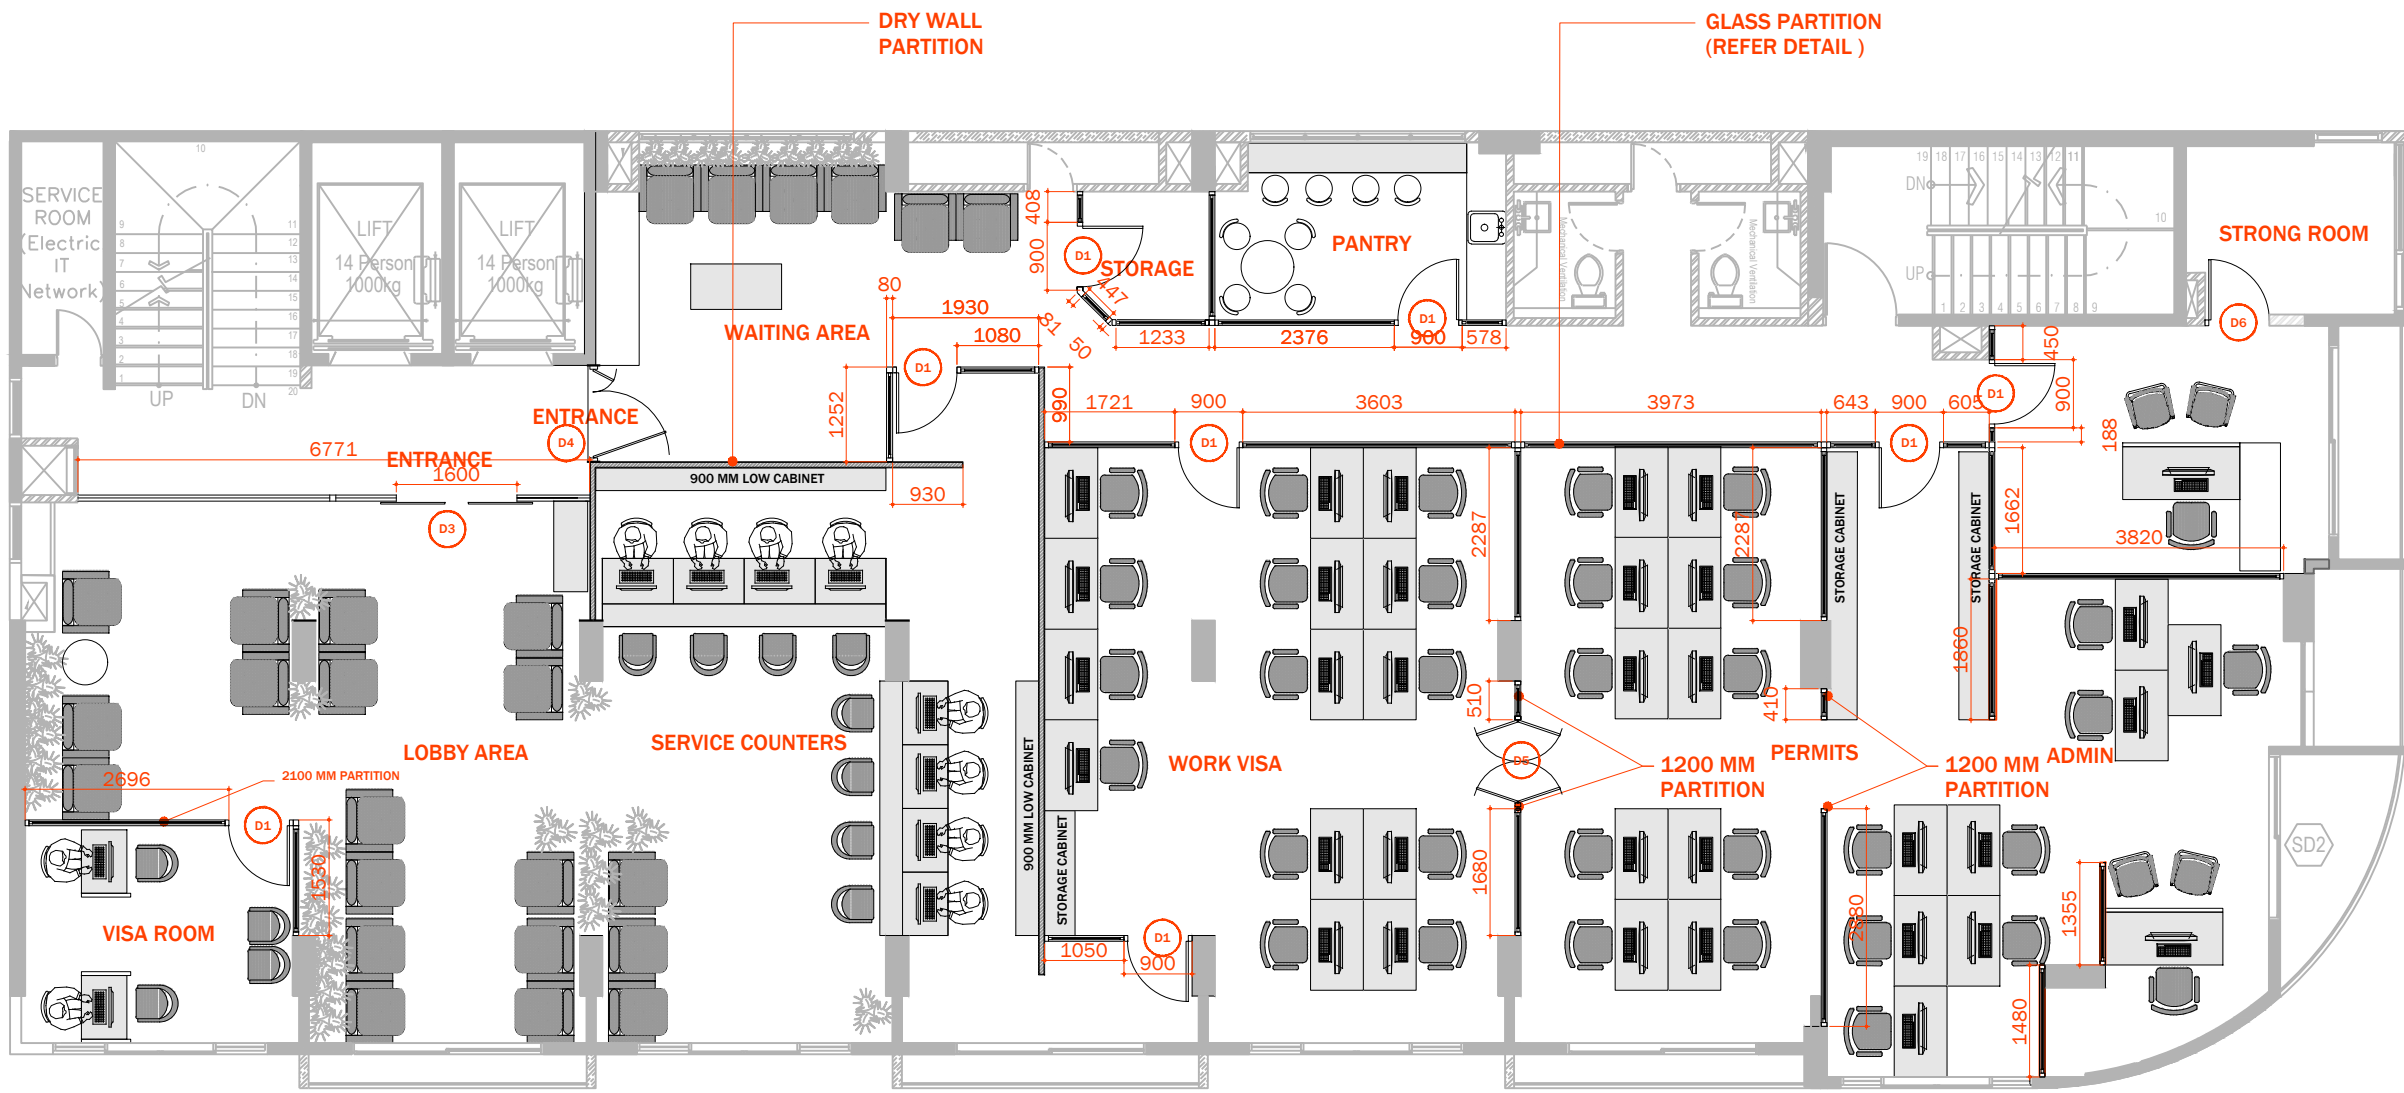

8TH FLOOR PARTITION LAYOUT

SCALE 1:100



- DRY PARTITION WALL
(ALUMINUM FRAMING WITH 9 MM CEMENT BOARD ON BOTH SIDES)
- GLASS PARTITION
(WHITE POWDER COAT ALUMINUM FRAMING WITH CLEAR GLASS)
REFER TO DETAILS

SHIYARCH

No.	Revision	Checked By	Date

Project Title:
**IMMIGRATION OFFICE
(AT STAR CLOUD BUILDING)**


Client:
MALDIVES IMMIGRATION

INTERIOR DESIGN

Drawing Title:
SITE PLAN

Architect: -	Interior Designer: -
Drawn By: SHIYA	Checked By: -
Paper: A3	Project No: -
Date: FEBRUARY 2021	Scale: AS GIVEN
Drawing No: D-01 /01	

Copyright: The concept and design in this drawing are the properties of shiyarch. unauthorized use of any kind or copying of whole or part of this drawing, concept or design or use on projects or sites other than specified on this drawing is prohibited and apply as terms and conditions under which the client is entitled to use the concept or design in this drawing.

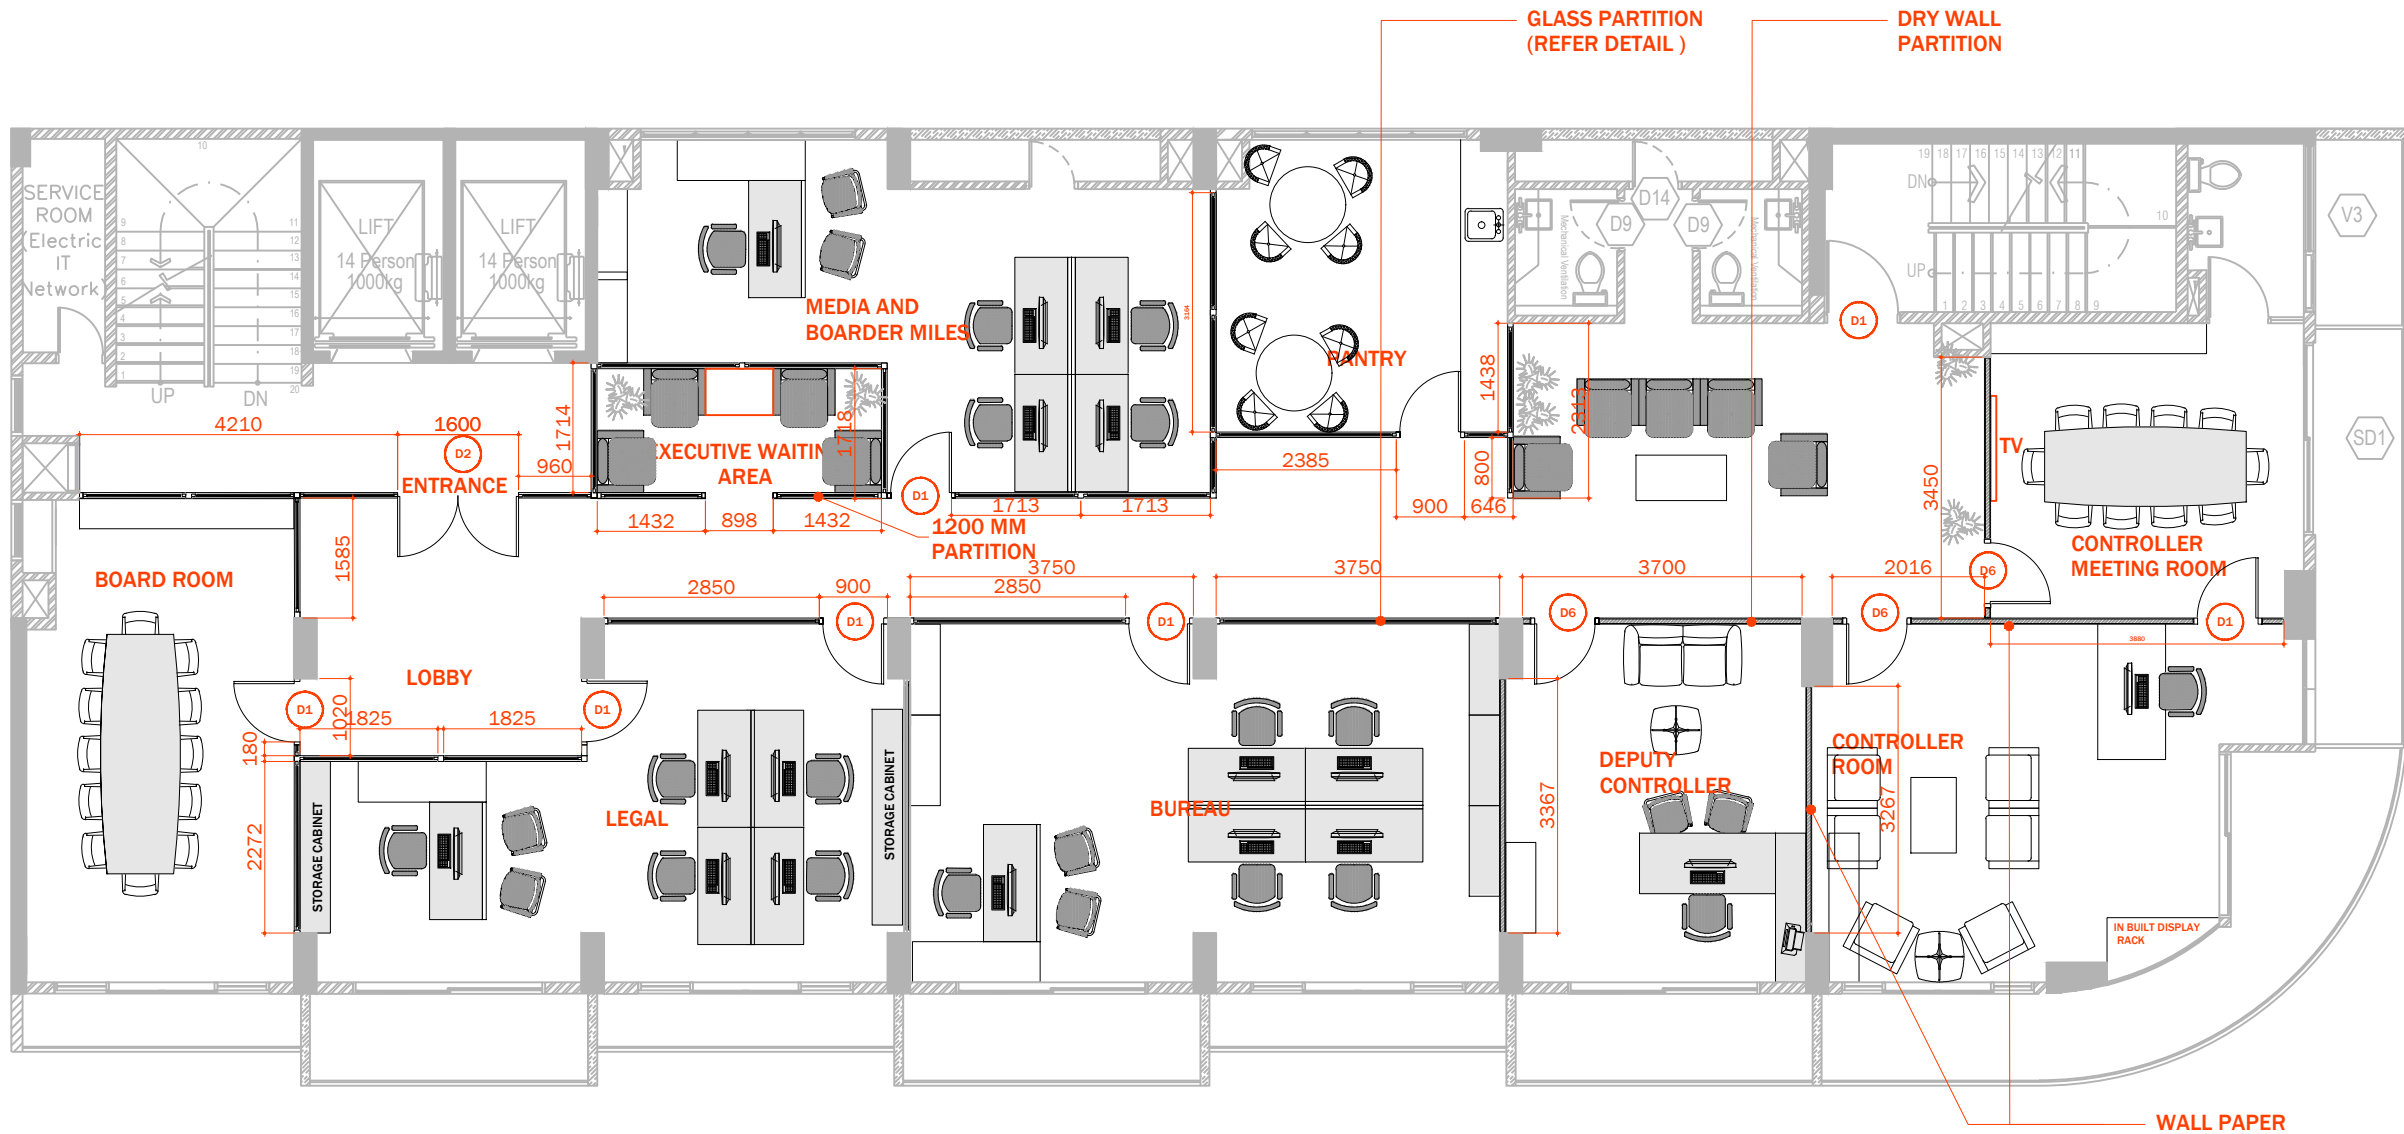

9TH FLOOR PARTITION LAYOUT

SCALE 1:100



- DRY PARTITION WALL (ALUMINUM FRAMING WITH 9 MM CEMENT BOARD ON BOTH SIDES) .
- GLASS PARTITION (WHITE POWDER COAT ALUMINUM FRAMING WITH CLEAR GLASS) REFER TO DETAILS

SHIYARCH

No.	Revision	Checked By	Date

Project Title:

IMMIGRATION OFFICE (AT STAR CLOUD BUILDING)


Client:
MALDIVES IMMIGRATION

INTERIOR DESIGN

Drawing Title:
SITE PLAN

Architect: -	Interior Designer: -
Drawn By: SHIYA	Checked By: -
Paper: A3	Project No: -
Date: FEBRUARY 2021	Scale: AS GIVEN
Drawing No: D-01 /01	

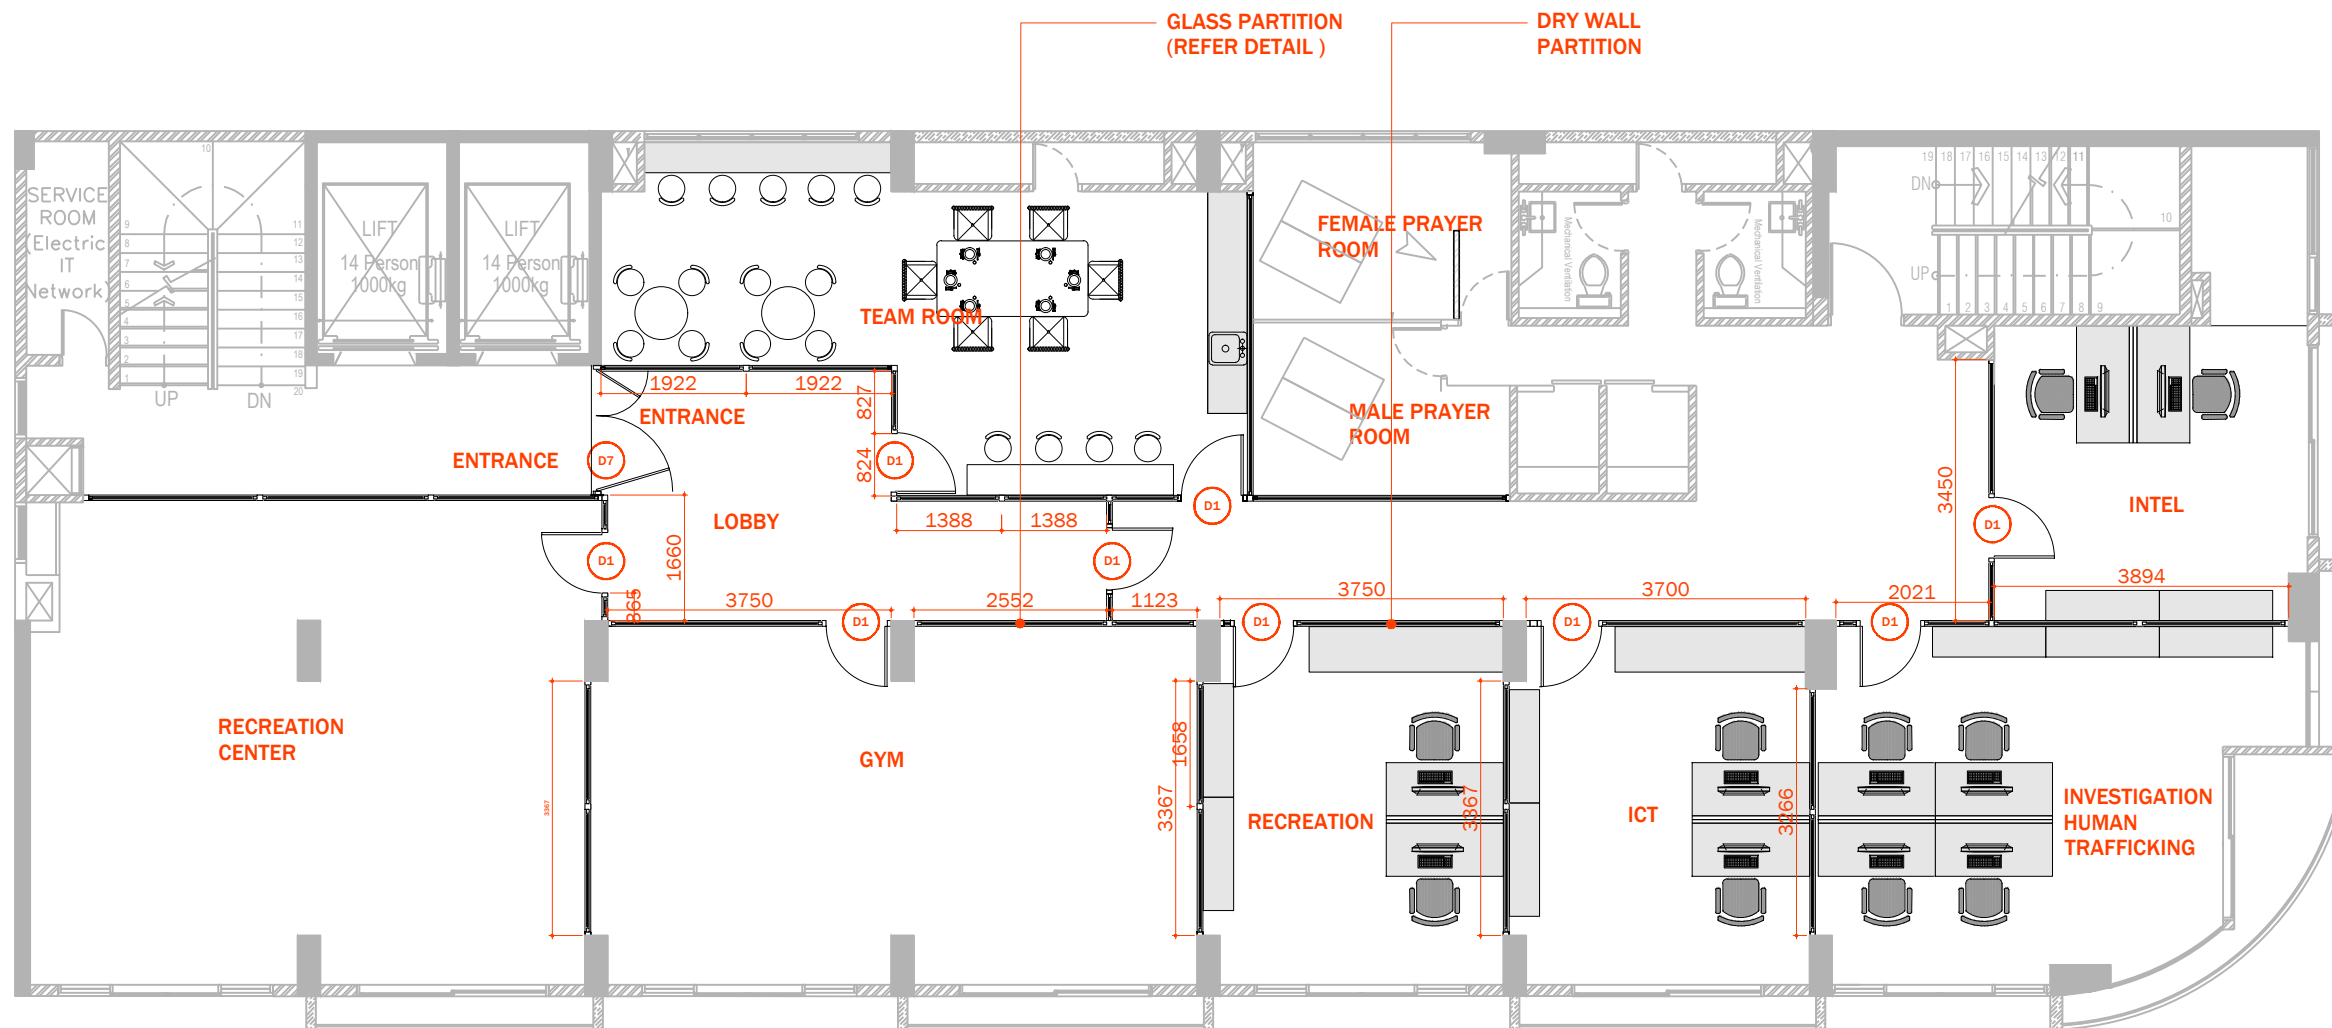

Copyright: The concept and design in this drawing are the properties of shiyarch. unauthorized use of any kind or copying of whole or part of this drawing, concept or design or use on projects or sites other than specified on this drawing is prohibited and apply as terms and conditions under which the client is entitled to use the concept or design in this drawing.



10TH FLOOR PARTITION LAYOUT

SCALE 1:100



-  DRY PARTITION WALL
(ALUMINUM FRAMING WITH 9 MM
CEMENT BOARD ON BOTH SIDES)
-  GLASS PARTITION
(WHITE POWDER COAT ALUMINUM
FRAMING WITH CLEAR GLASS)
REFER TO DETAILS

SHIYARCH

No.	Revision	Checked By	Date

Project Title:
**IMMIGRATION OFFICE
(AT STAR CLOUD BUILDING)**


Client:
MALDIVES IMMIGRATION

INTERIOR DESIGN

Drawing Title:
SITE PLAN

Architect: -	Interior Designer: -
Drawn By: SHIYA	Checked By: -
Paper: A3	Project No: -
Date: FEBRUARY 2021	Scale: AS GIVEN
Drawing No: D-01 /01	

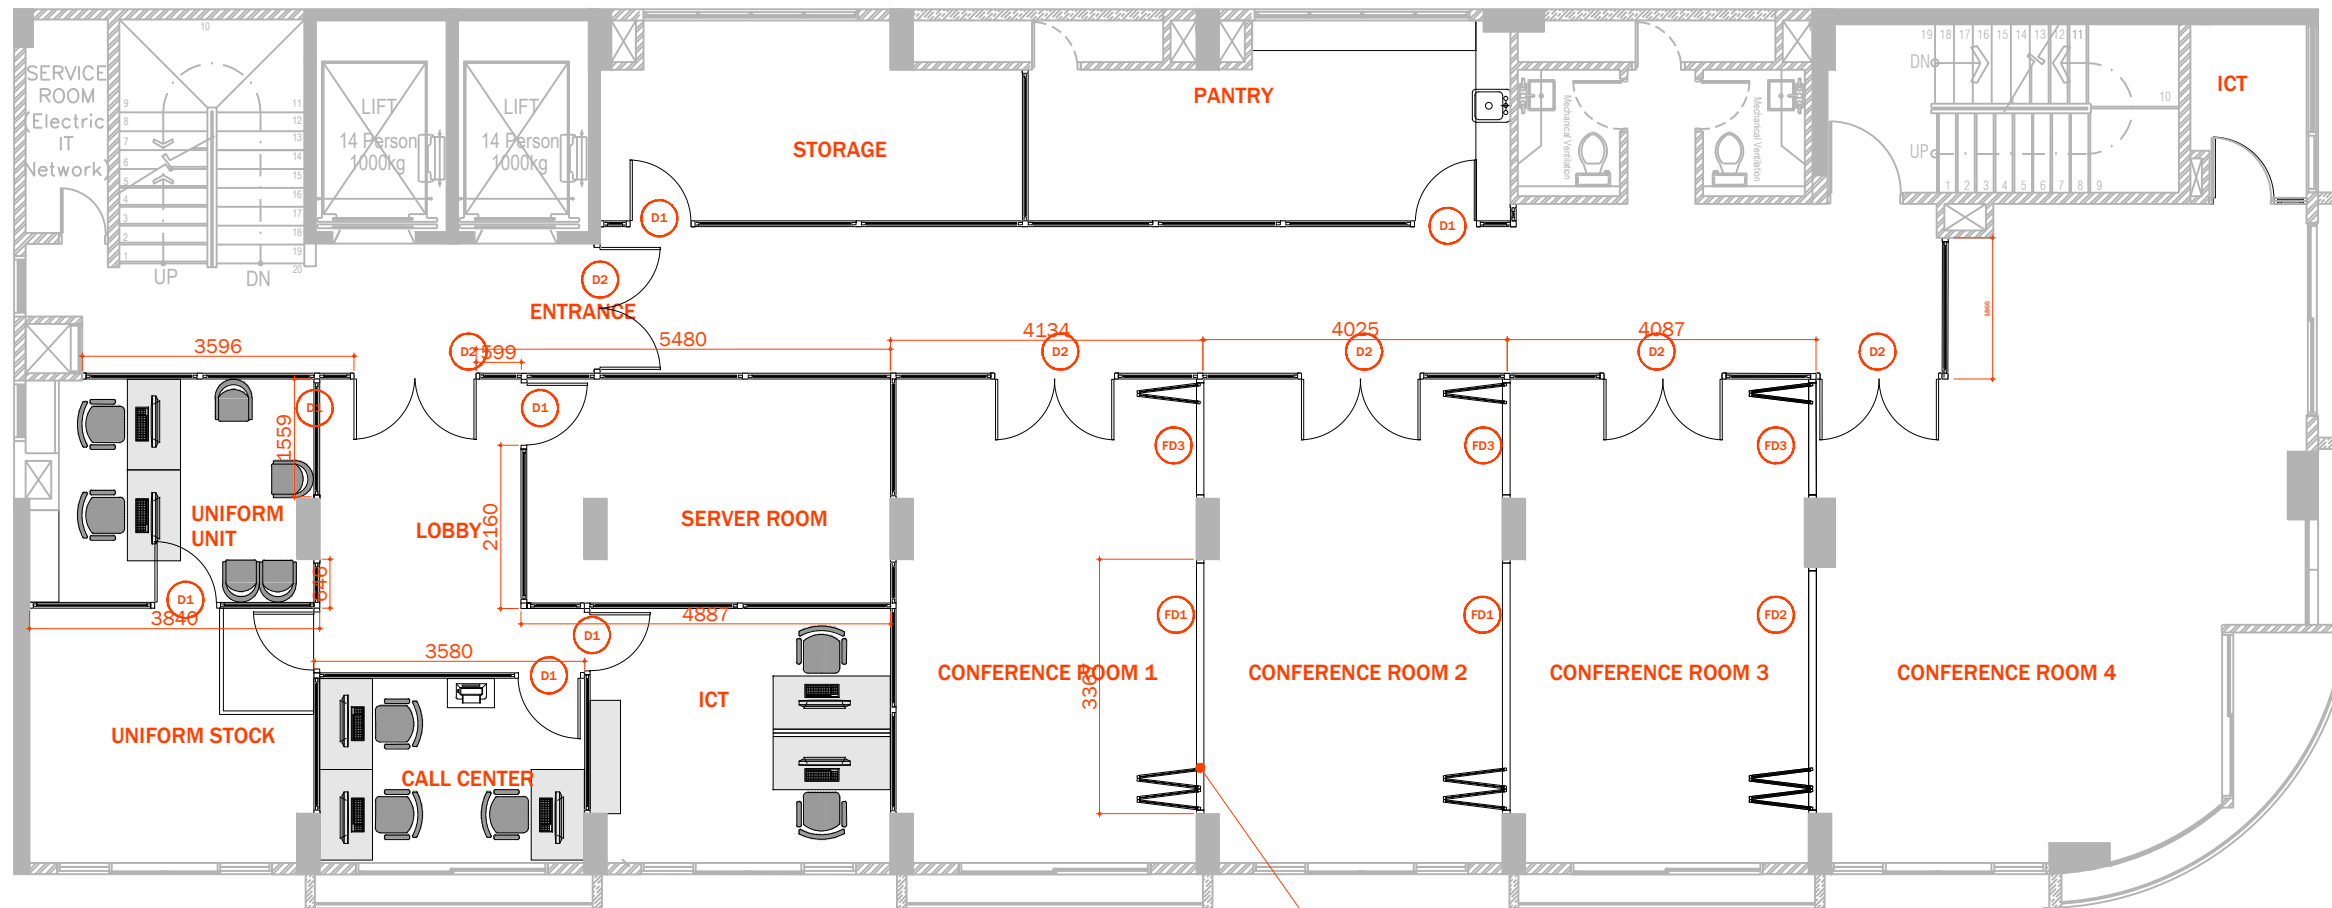

Copyright: The concept and design in this drawing are the properties of shiyarch. unauthorized use of any kind or copying of whole or part of this drawing, concept or design or use on projects or sites other than specified on this drawing is prohibited and apply as terms and conditions under which the client is entitled to use the concept or design in this drawing.



11TH FLOOR PARTITION LAYOUT

SCALE 1:100



-  DRY PARTITION WALL
(ALUMINUM FRAMING WITH 9 MM CEMENT BOARD ON BOTH SIDES)
-  GLASS PARTITION
(WHITE POWDER COAT ALUMINUM FRAMING WITH CLEAR GLASS)
REFER TO DETAILS

REFER FOLDING/
SLIDING DETAIL

SHIYARCH

No.	Revision	Checked By	Date

Project Title:
**IMMIGRATION OFFICE
(AT STAR CLOUD BUILDING)**




Client:
MALDIVES IMMIGRATION

INTERIOR DESIGN

Drawing Title:
SITE PLAN

Architect: -	Interior Designer: -
Drawn By: SHIYA	Checked By: -
Paper: A3	Project No: -
Date: FEBRUARY 2021	Scale: AS GIVEN
Drawing No: D-01 /01	

Copyright: The concept and design in this drawing are the properties of shiyarch. unauthorized use of any kind or copying of whole or part of this drawing, concept or design or use on projects or sites other than specified on this drawing is prohibited and apply as terms and conditions under which the client is entitled to use the concept or design in this drawing.

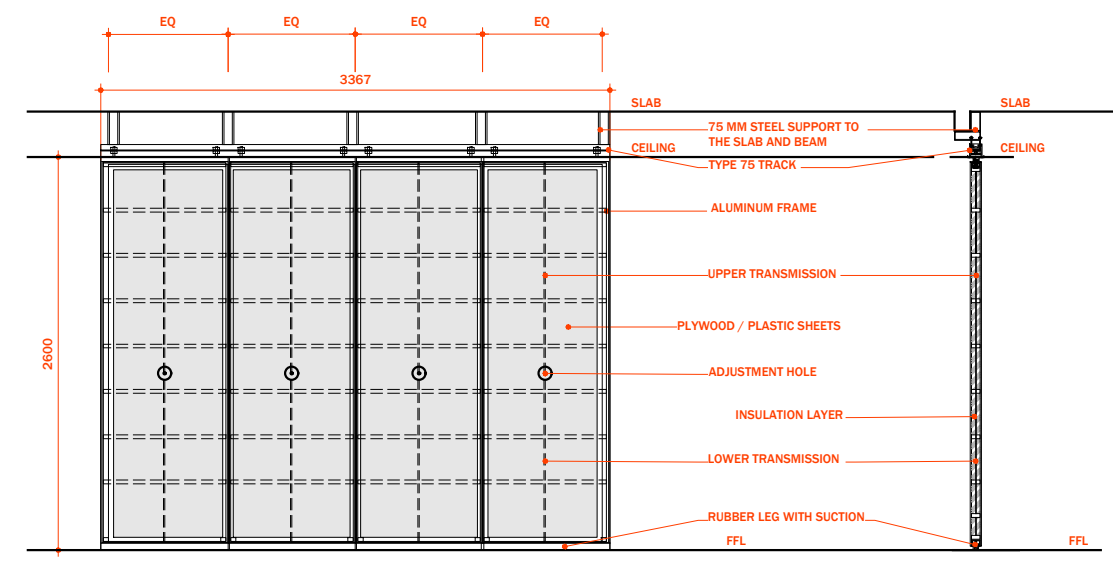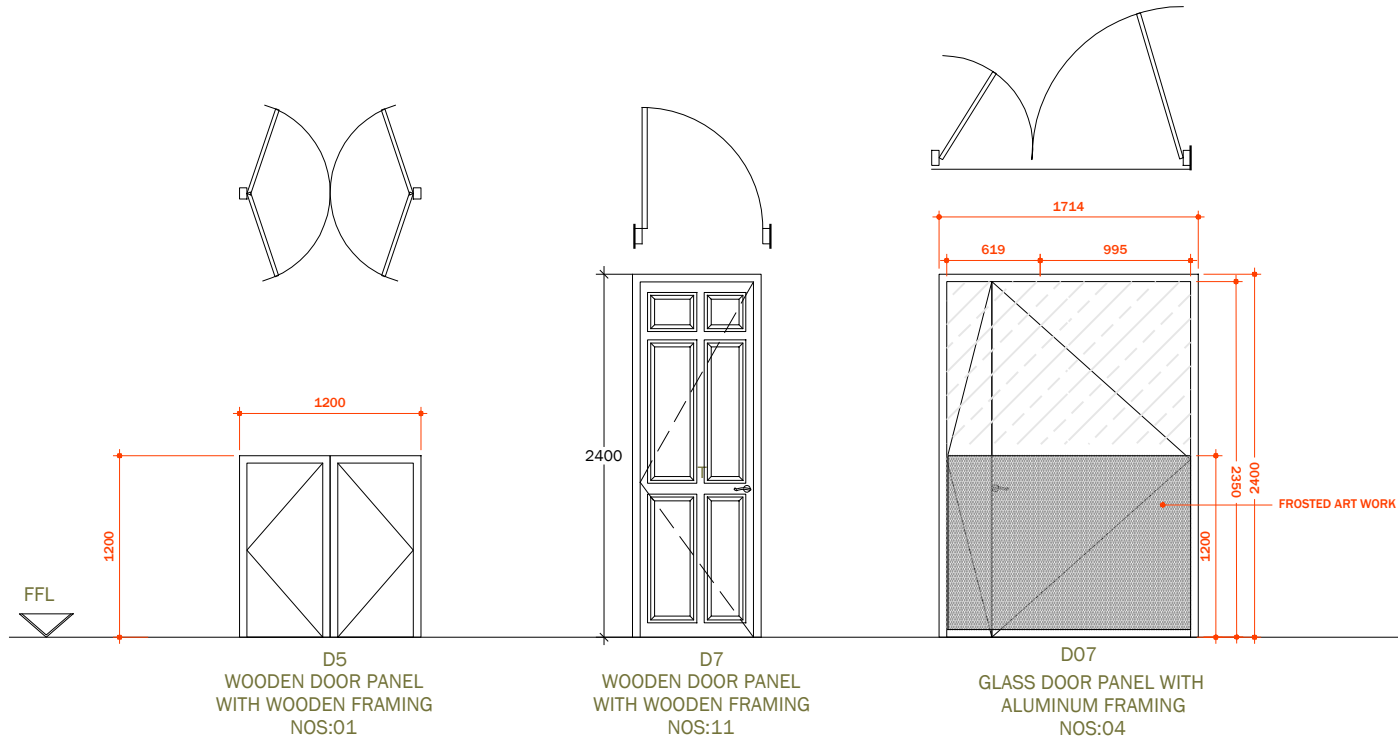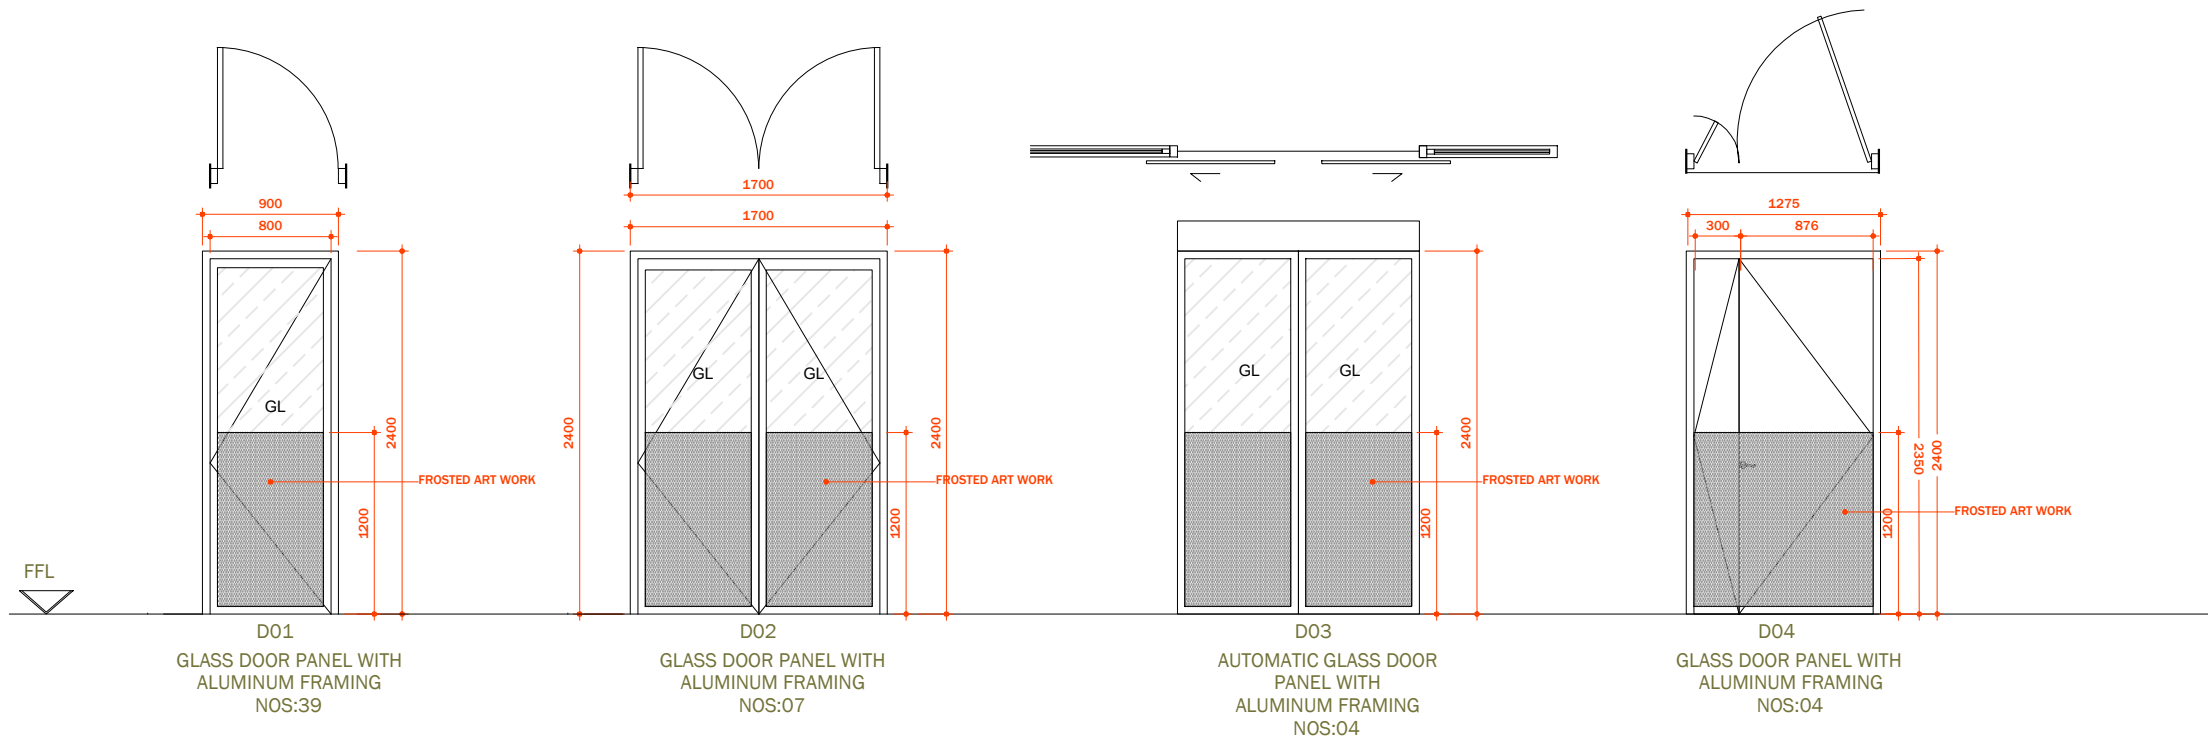

1 FOLDING SLIDING DOOR DETAIL 1 SCALE: 1:50

SHIYARCH

No.	Revision	Checked By	Date

Project Title:
IMMIGRATION OFFICE (AT STAR CLOUD BUILDING)



Client:
MALDIVES IMMIGRATION

INTERIOR DESIGN

Drawing Title:
SITE PLAN

Architect: -	Interior Designer: -
Drawn By: SHIYA	Checked By: -
Paper: A3	Project No: -
Date: FEBRUARY 2021	Scale: AS GIVEN
Drawing No: D-01 / 01	

Copyright: The concept and design in this drawing are the properties of shiyarch. unauthorized use of any kind or copying of whole or part of this drawing, concept or design or use on projects or sites other than specified on this drawing is prohibited and apply as terms and conditions under which the client is entitled to use the concept or design in this drawing.

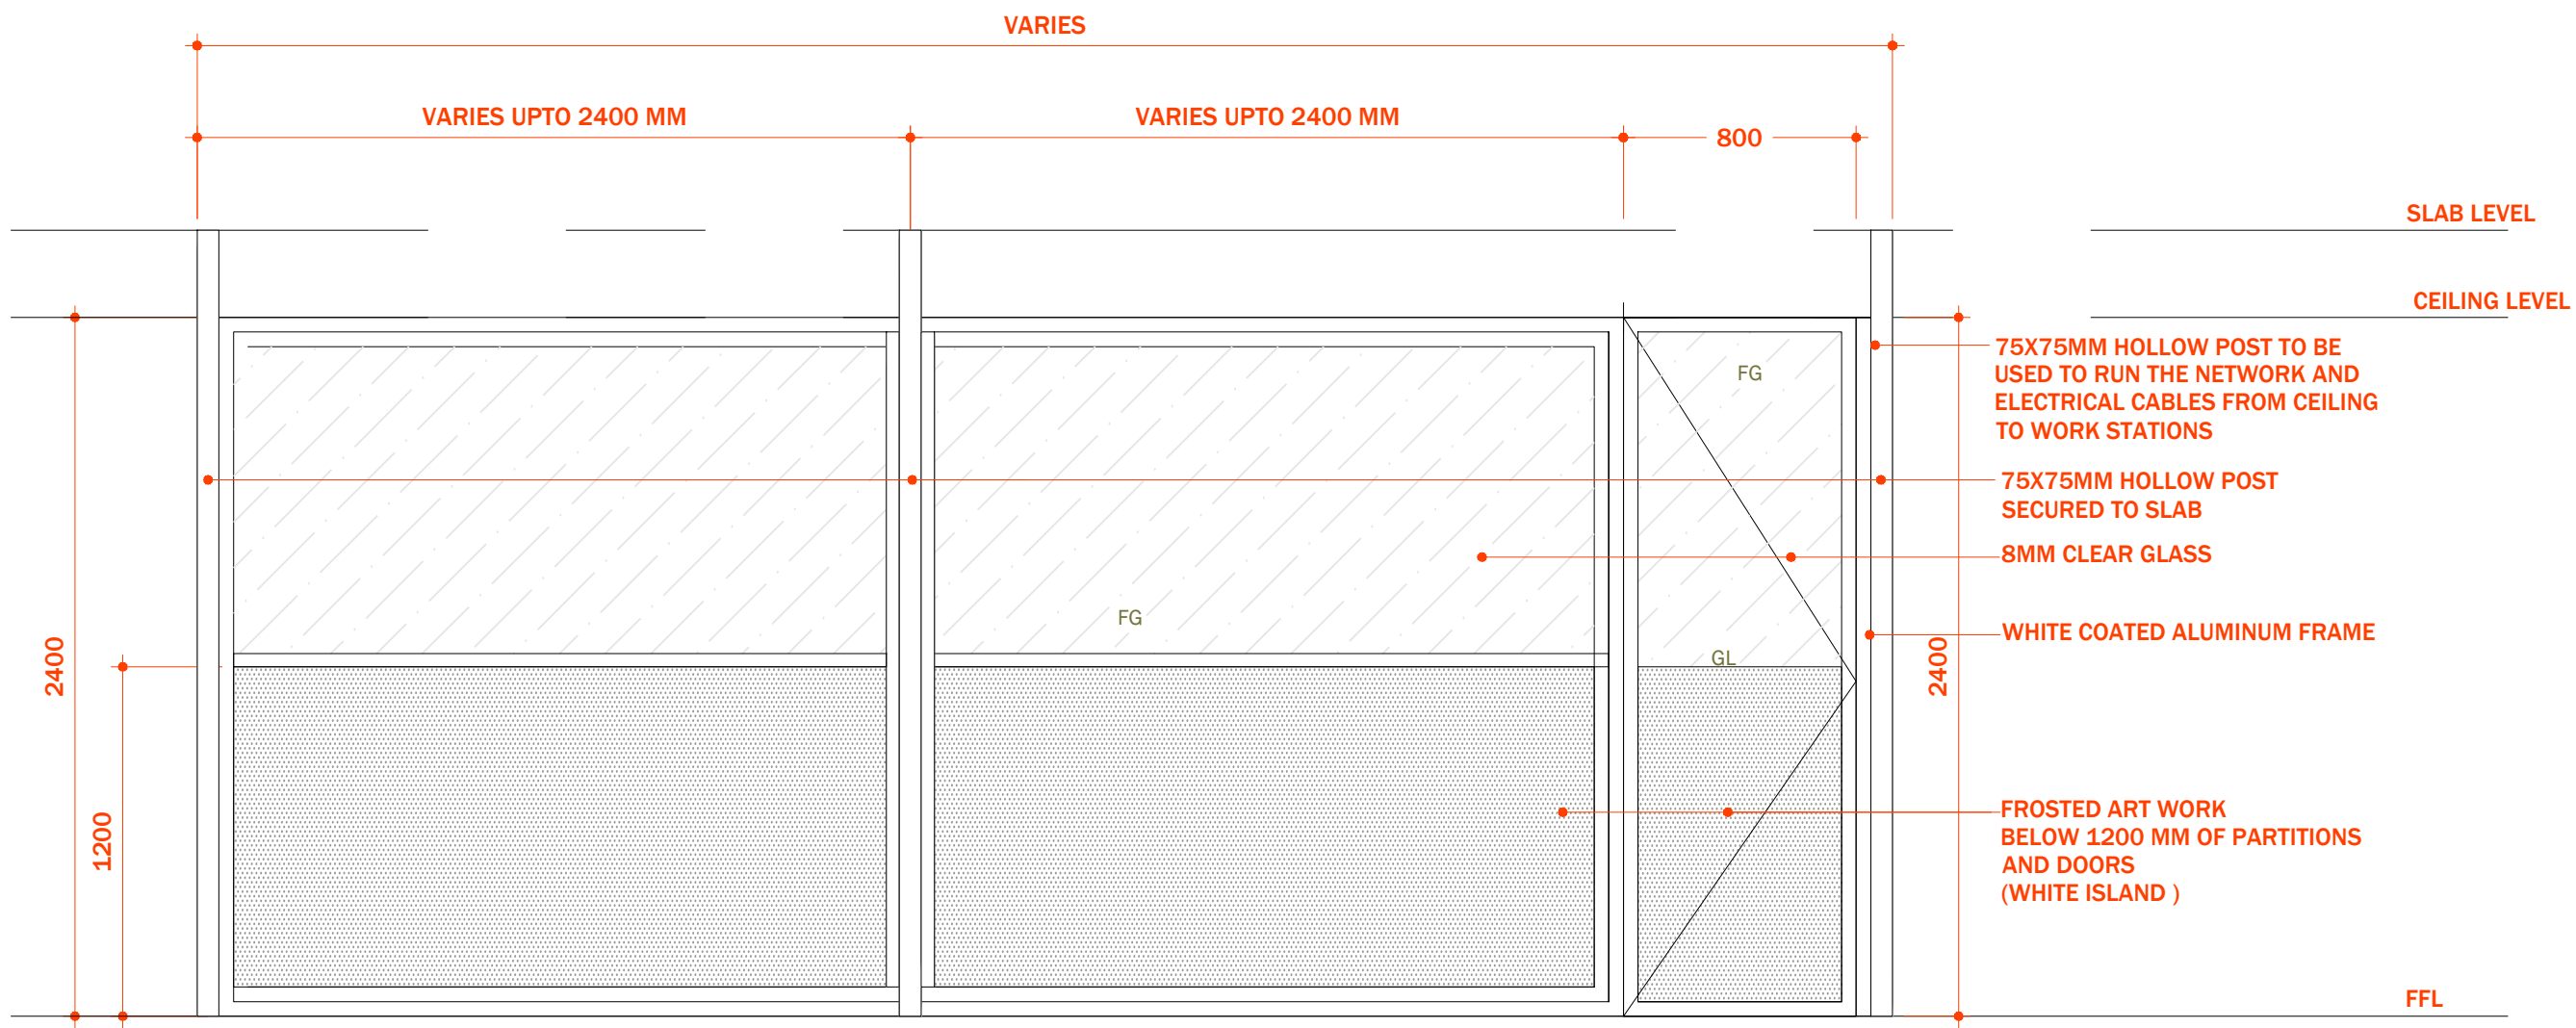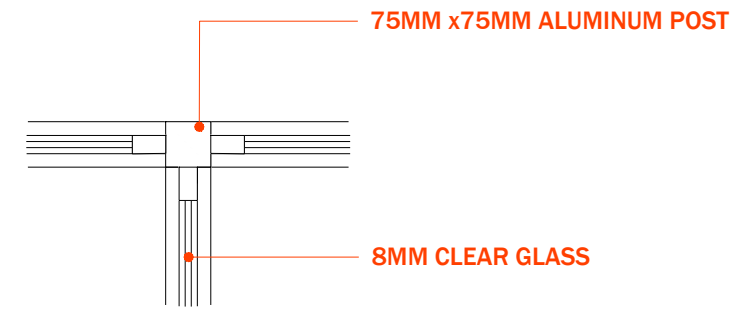

SHIYARCH

No.	Revision	Checked By	Date

Project Title:
**IMMIGRATION OFFICE
(AT STAR CLOUD BUILDING)**

Client:
MALDIVES IMMIGRATION


INTERIOR DESIGN

Drawing Title:
SITE PLAN

Architect: -	Interior Designer: -
Drawn By: SHIYA	Checked By: -
Paper: A3	Project No: -
Date: FEBRUARY 2021	Scale: AS GIVEN
Drawing No: D-01 /01	

Copyright: The concept and design in this drawing are the properties of shiyarch. unauthorized use of any kind or copying of whole or part of this drawing, concept or design or use on projects or sites other than specified on this drawing is prohibited and apply as terms and conditions under which the client is entitled to use the concept or design in this drawing.

**1 PARTITION DETAIL 01
SCALE: 1:50**

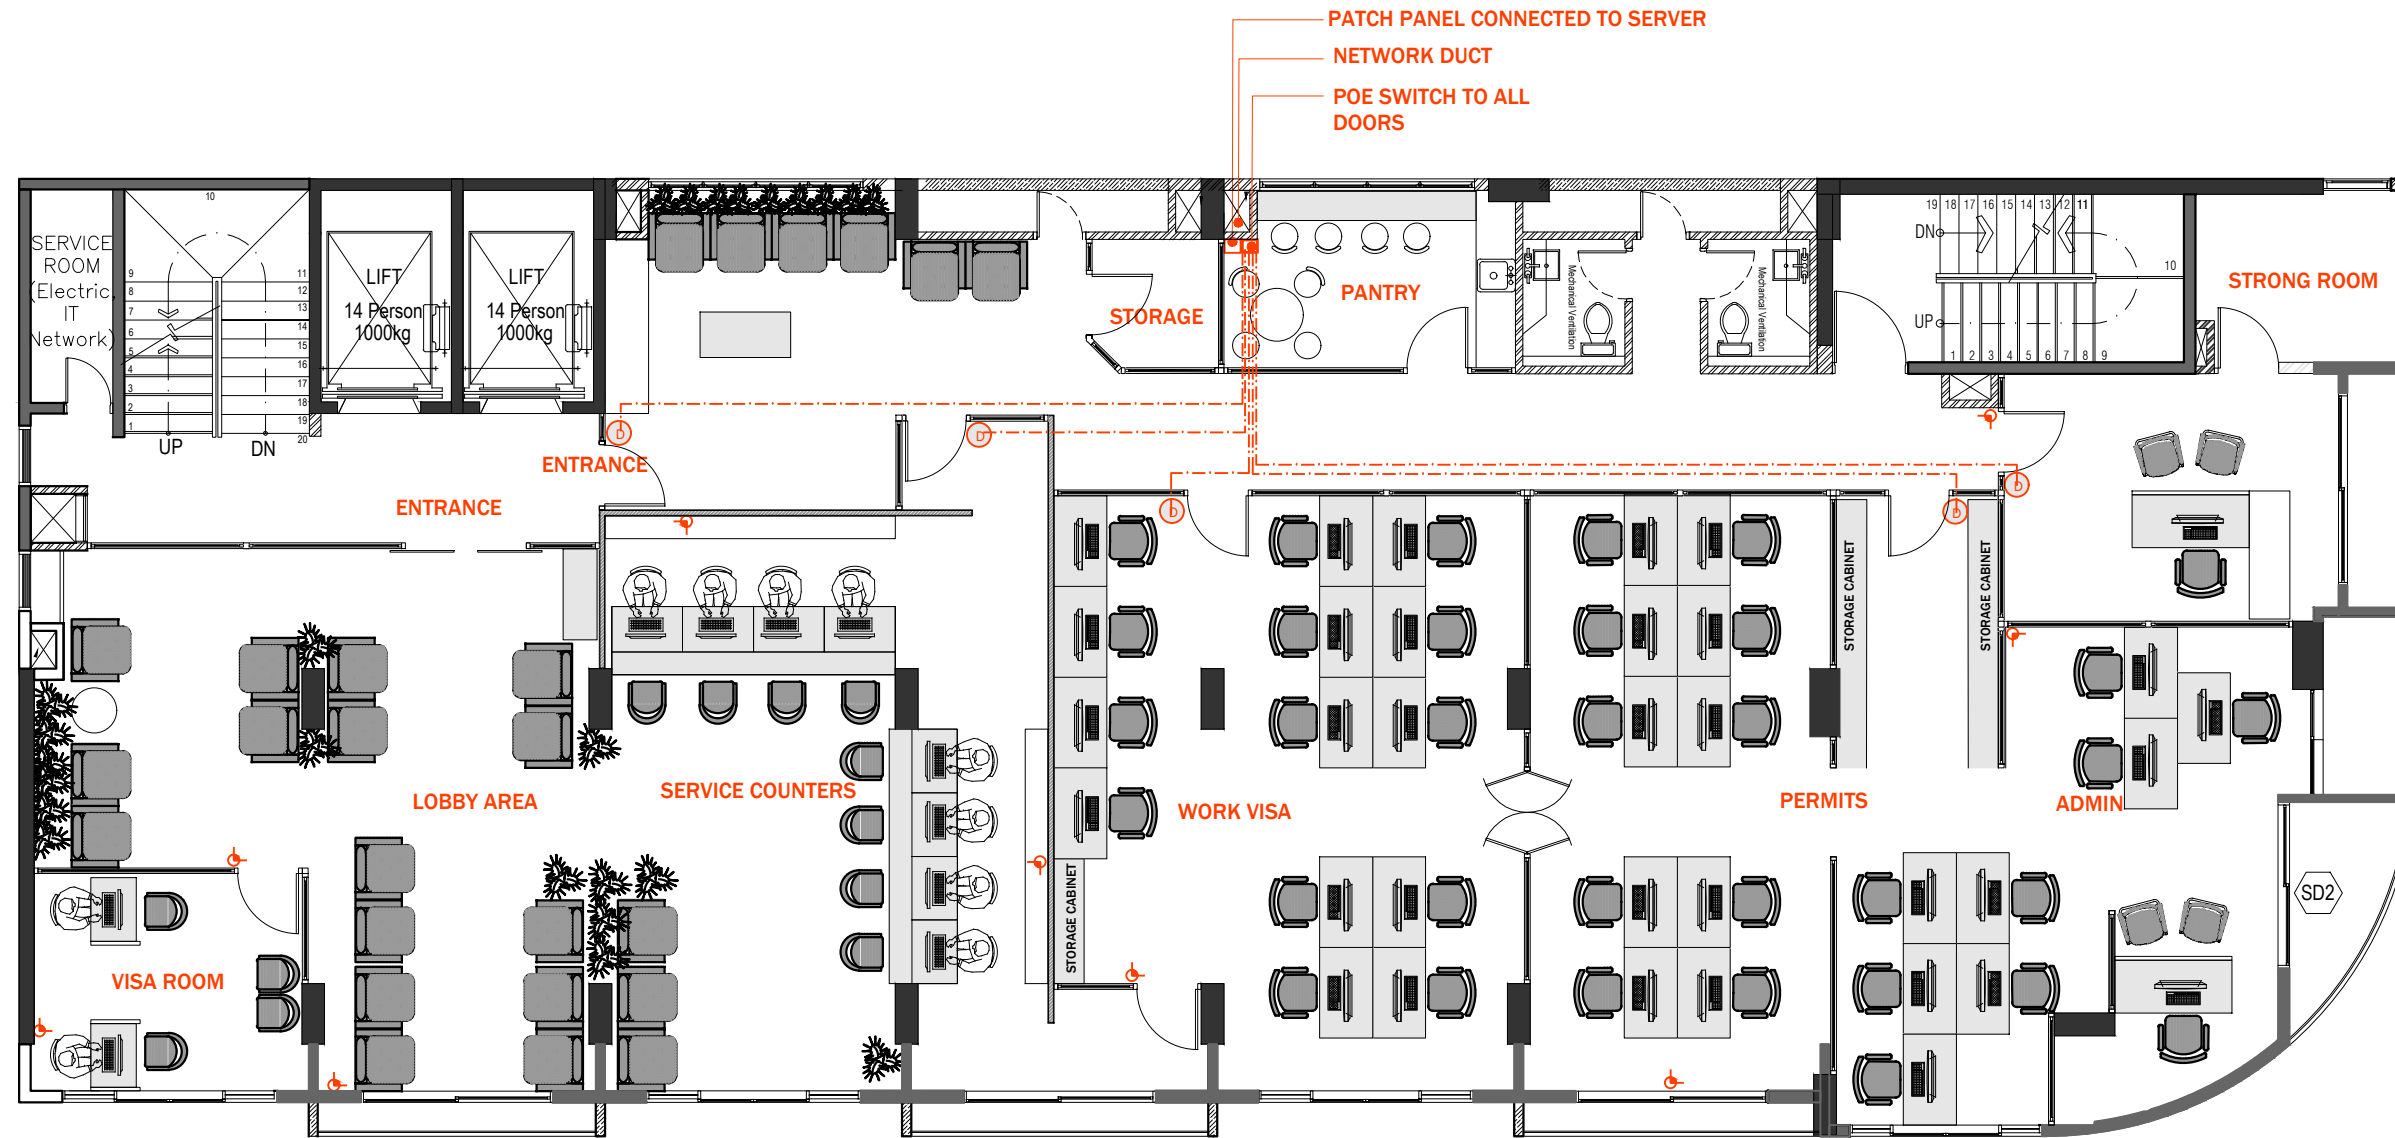

8TH FLOOR NETWORK CABLE , DOOR LOCK AND CCTV LAYOUT

SCALE 1:100



LEGEND	
SYMBOL	DESCRIPTION
(b)	DOOR LOCK
	CCTV CAMERA
- - - - -	CAT6 CABLE

- IMPORTANT:
- ALL CAMERA TO BE CONNECTED TO SERVER ROOM
 - ALL NETWORK POINTS TO BE CONNECTED TO SERVER ROOM
 - ALL NETWORK POINTS FROM WORK STATIONS TO BE CONNECTED TO THE SERVER ROOM

SHIYARCH

No.	Revision	Checked By	Date

Project Title:

IMMIGRATION OFFICE
(AT STAR CLOUD BUILDING)

Client:


MALDIVES IMMIGRATION

INTERIOR DESIGN

Drawing Title:
SITE PLAN

Architect:	Interior Designer:
SHIYA	
Drawn By:	Checked By:
A3	
Date:	Scale:
FEBRUARY 2021	AS GIVEN
Drawing No:	D-01 /01

Copyright: The concept and design in this drawing are the properties of shiyarch. unauthorized use of any kind or copying of whole or part of this drawing, concept or design or use on projects or sites other than specified on this drawing is prohibited and apply as terms and conditions under which the client is entitled to use the concept or design in this drawing.

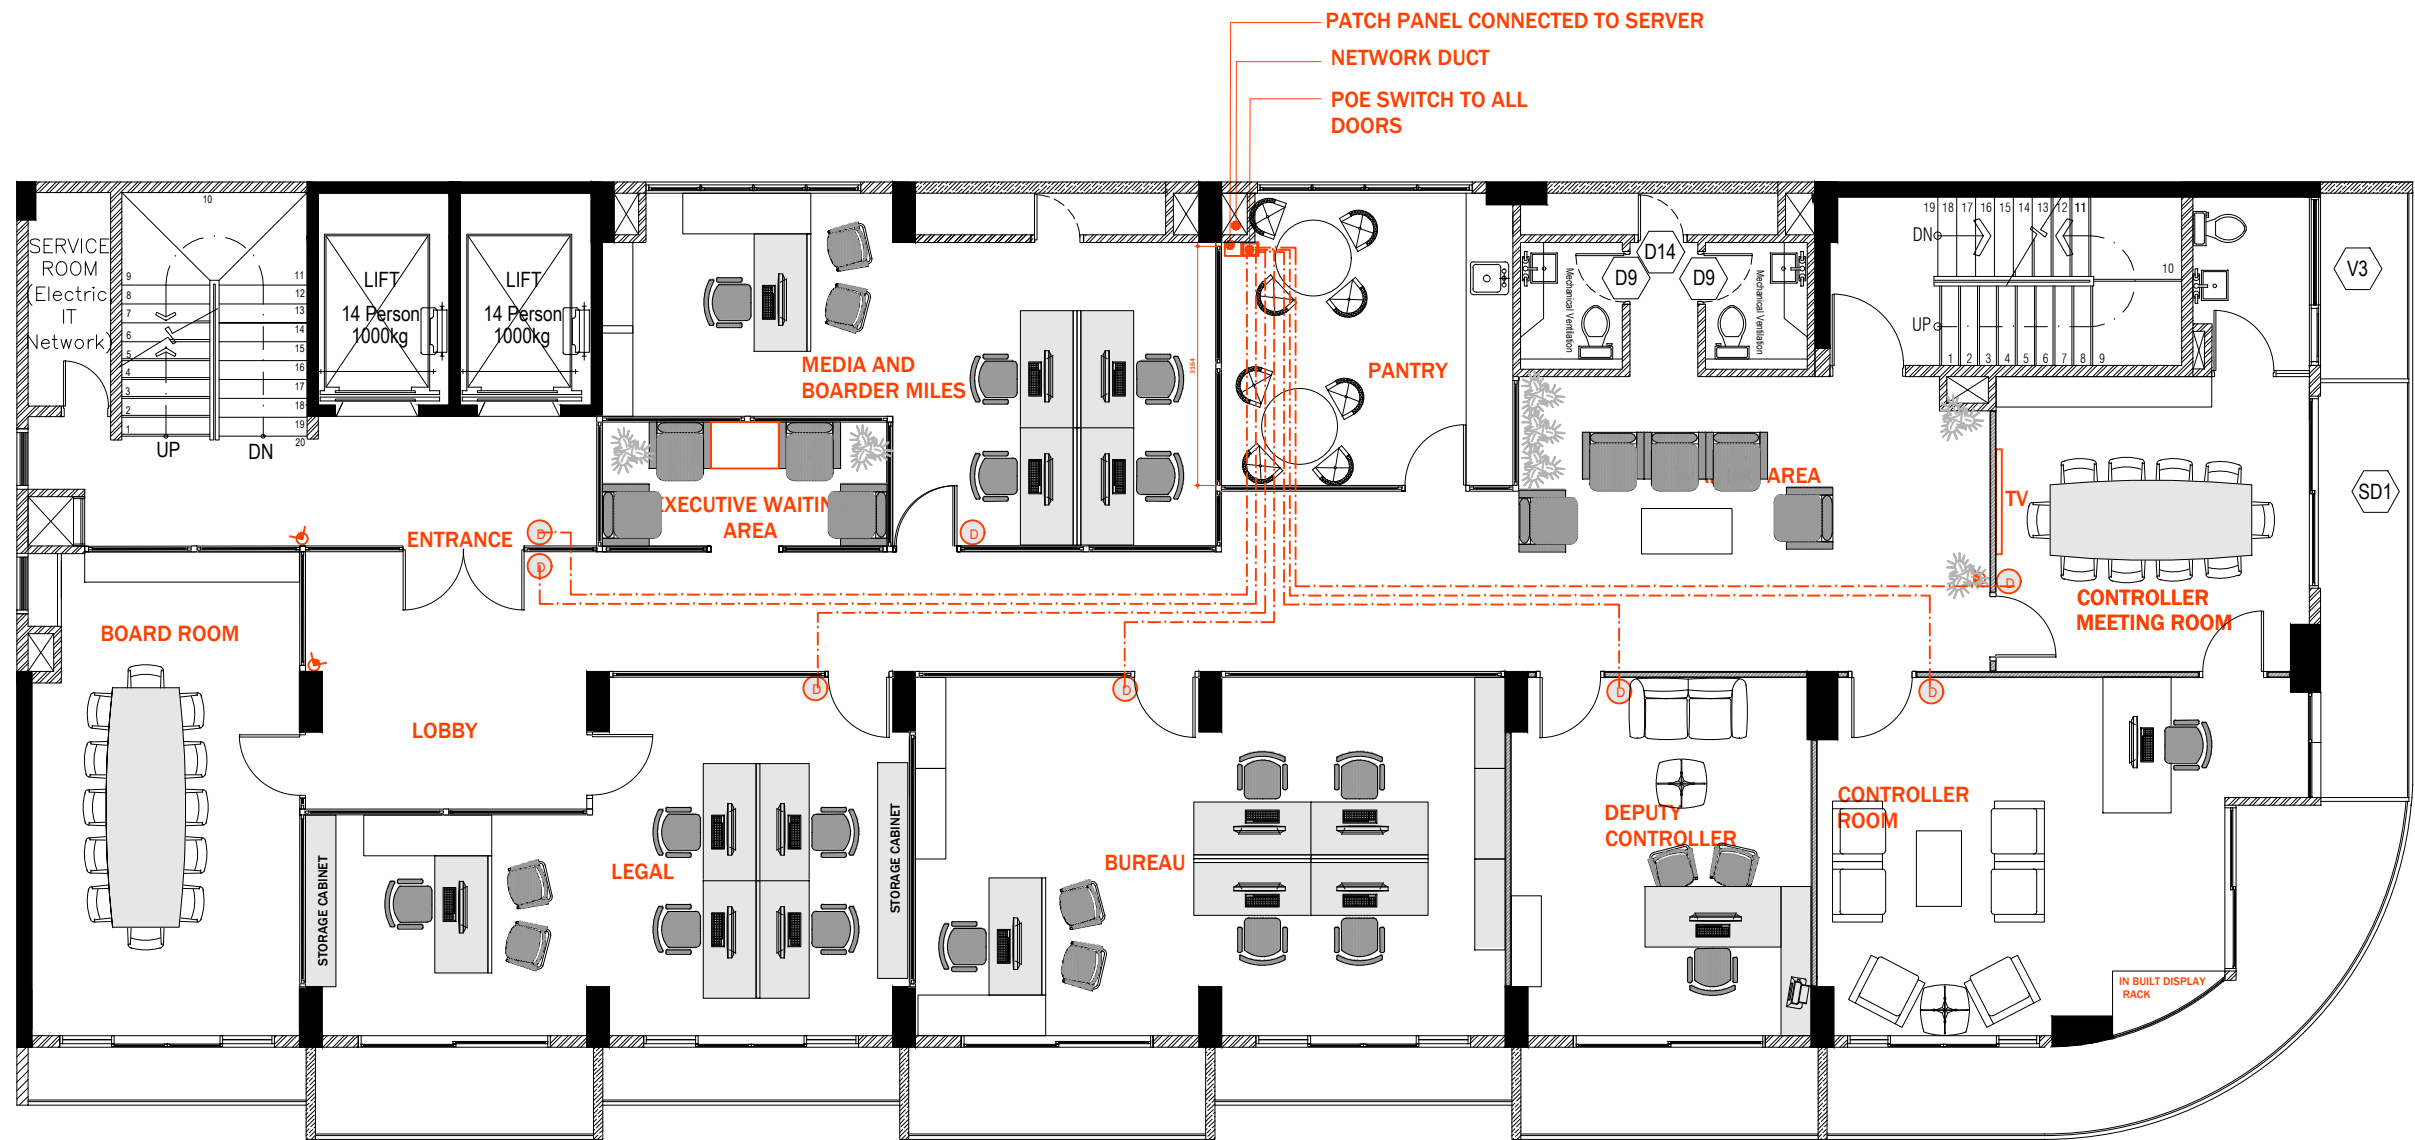

9TH FLOOR NETWORK CABLE , DOOR LOCK AND CCTV LAYOUT
SCALE 1:100



LEGEND	
SYMBOL	DESCRIPTION
	DOOR LOCK
	CCTV CAMERA
	CAT6 CABLE

IMPORTANT:

- ALL CAMERA TO BE CONNECTED TO SERVER ROOM
- ALL NETWORK POINTS TO BE CONNECTED TO SERVER ROOM
- ALL NETWORK POINTS FROM WORK STATIONS TO BE CONNECTED TO THE SERVER ROOM

No.	Revision	Checked By	Date

Project Title:
**IMMIGRATION OFFICE
(AT STAR CLOUD BUILDING)**


Client:
MALDIVES IMMIGRATION

INTERIOR DESIGN

Drawing Title:
SITE PLAN

Architect: -	Interior Designer: -
Drawn By: SHIYA	Checked By: -
Paper: A3	Project No: -
Date: FEBRUARY 2021	Scale: AS GIVEN
Drawing No: D-01 /01	

Copyright: The concept and design in this drawing are the properties of shiyarch. unauthorized use of any kind or copying of whole or part of this drawing, concept or design or use on projects or sites other than specified on this drawing is prohibited and apply as terms and conditions under which the client is entitled to use the concept or design in this drawing.

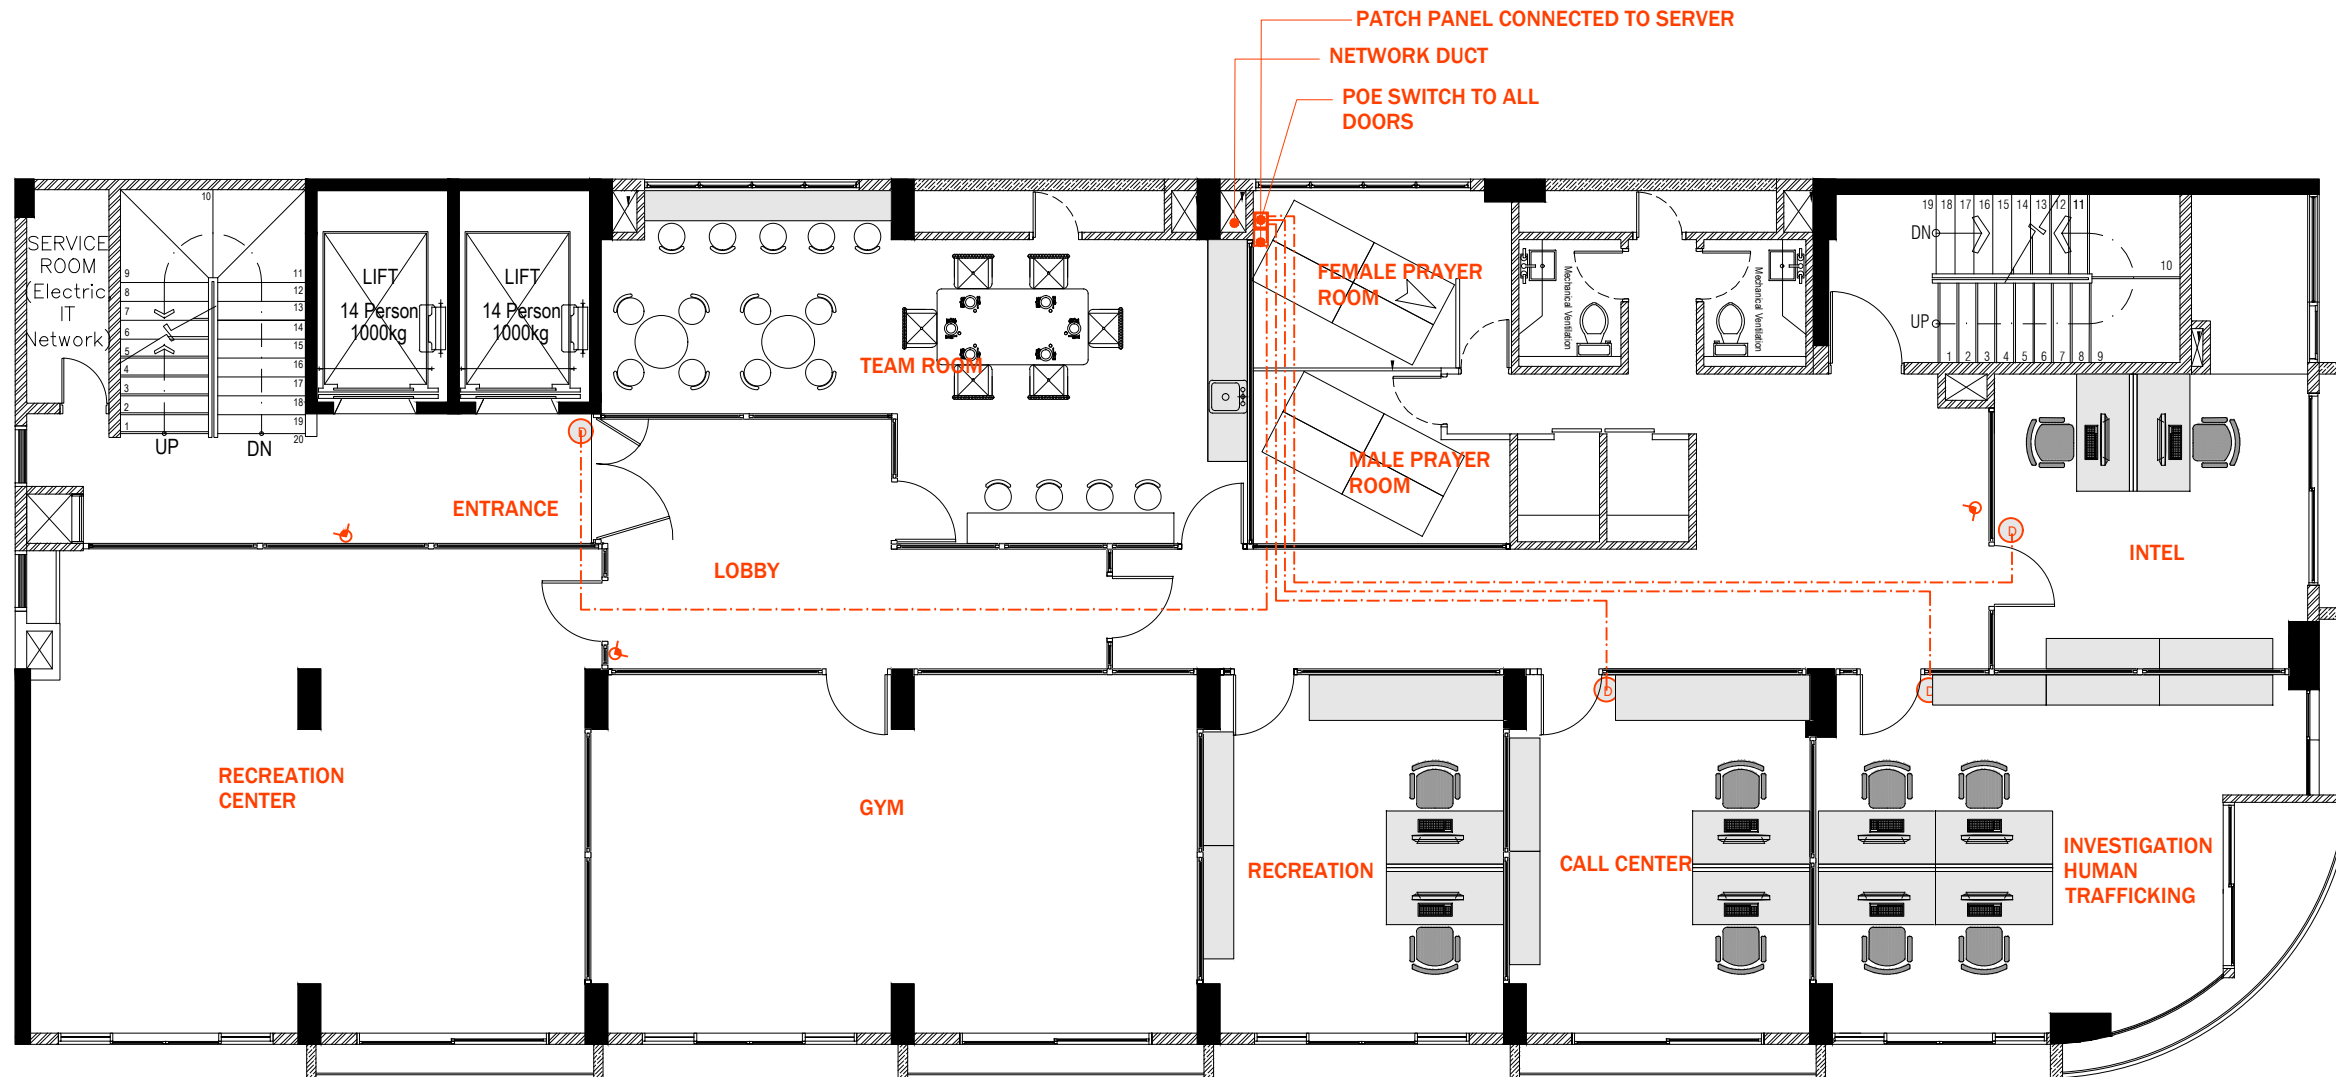

10TH FLOOR NETWORK CABLE , DOOR LOCK AND CCTV LAYOUT

SCALE 1:100



LEGEND	
SYMBOL	DESCRIPTION
	DOOR LOCK
	CCTV CAMERA
	CAT6 CABLE

- IMPORTANT:
- ALL CAMERA TO BE CONNECTED TO SERVER ROOM
 - ALL NETWORK POINTS TO BE CONNECTED TO SERVER ROOM
 - ALL NETWORK POINTS FROM WORK STATIONS TO BE CONNECTED TO THE SERVER ROOM

SHIYARCH

No.	Revision	Checked By	Date

Project Title:
IMMIGRATION OFFICE
(AT STAR CLOUD BUILDING)


Client:
MALDIVES IMMIGRATION

INTERIOR DESIGN

Drawing Title:
SITE PLAN

Architect: -	Interior Designer: -
Drawn By: SHIYA	Checked By: -
Paper: A3	Project No: -
Date: FEBRUARY 2021	Scale: AS GIVEN
Drawing No: D-01 /01	

Copyright: The concept and design in this drawing are the properties of shiyarch. unauthorized use of any kind or copying of whole or part of this drawing, concept or design or use on projects or sites other than specified on this drawing is prohibited and apply as terms and conditions under which the client is entitled to use the concept or design in this drawing.

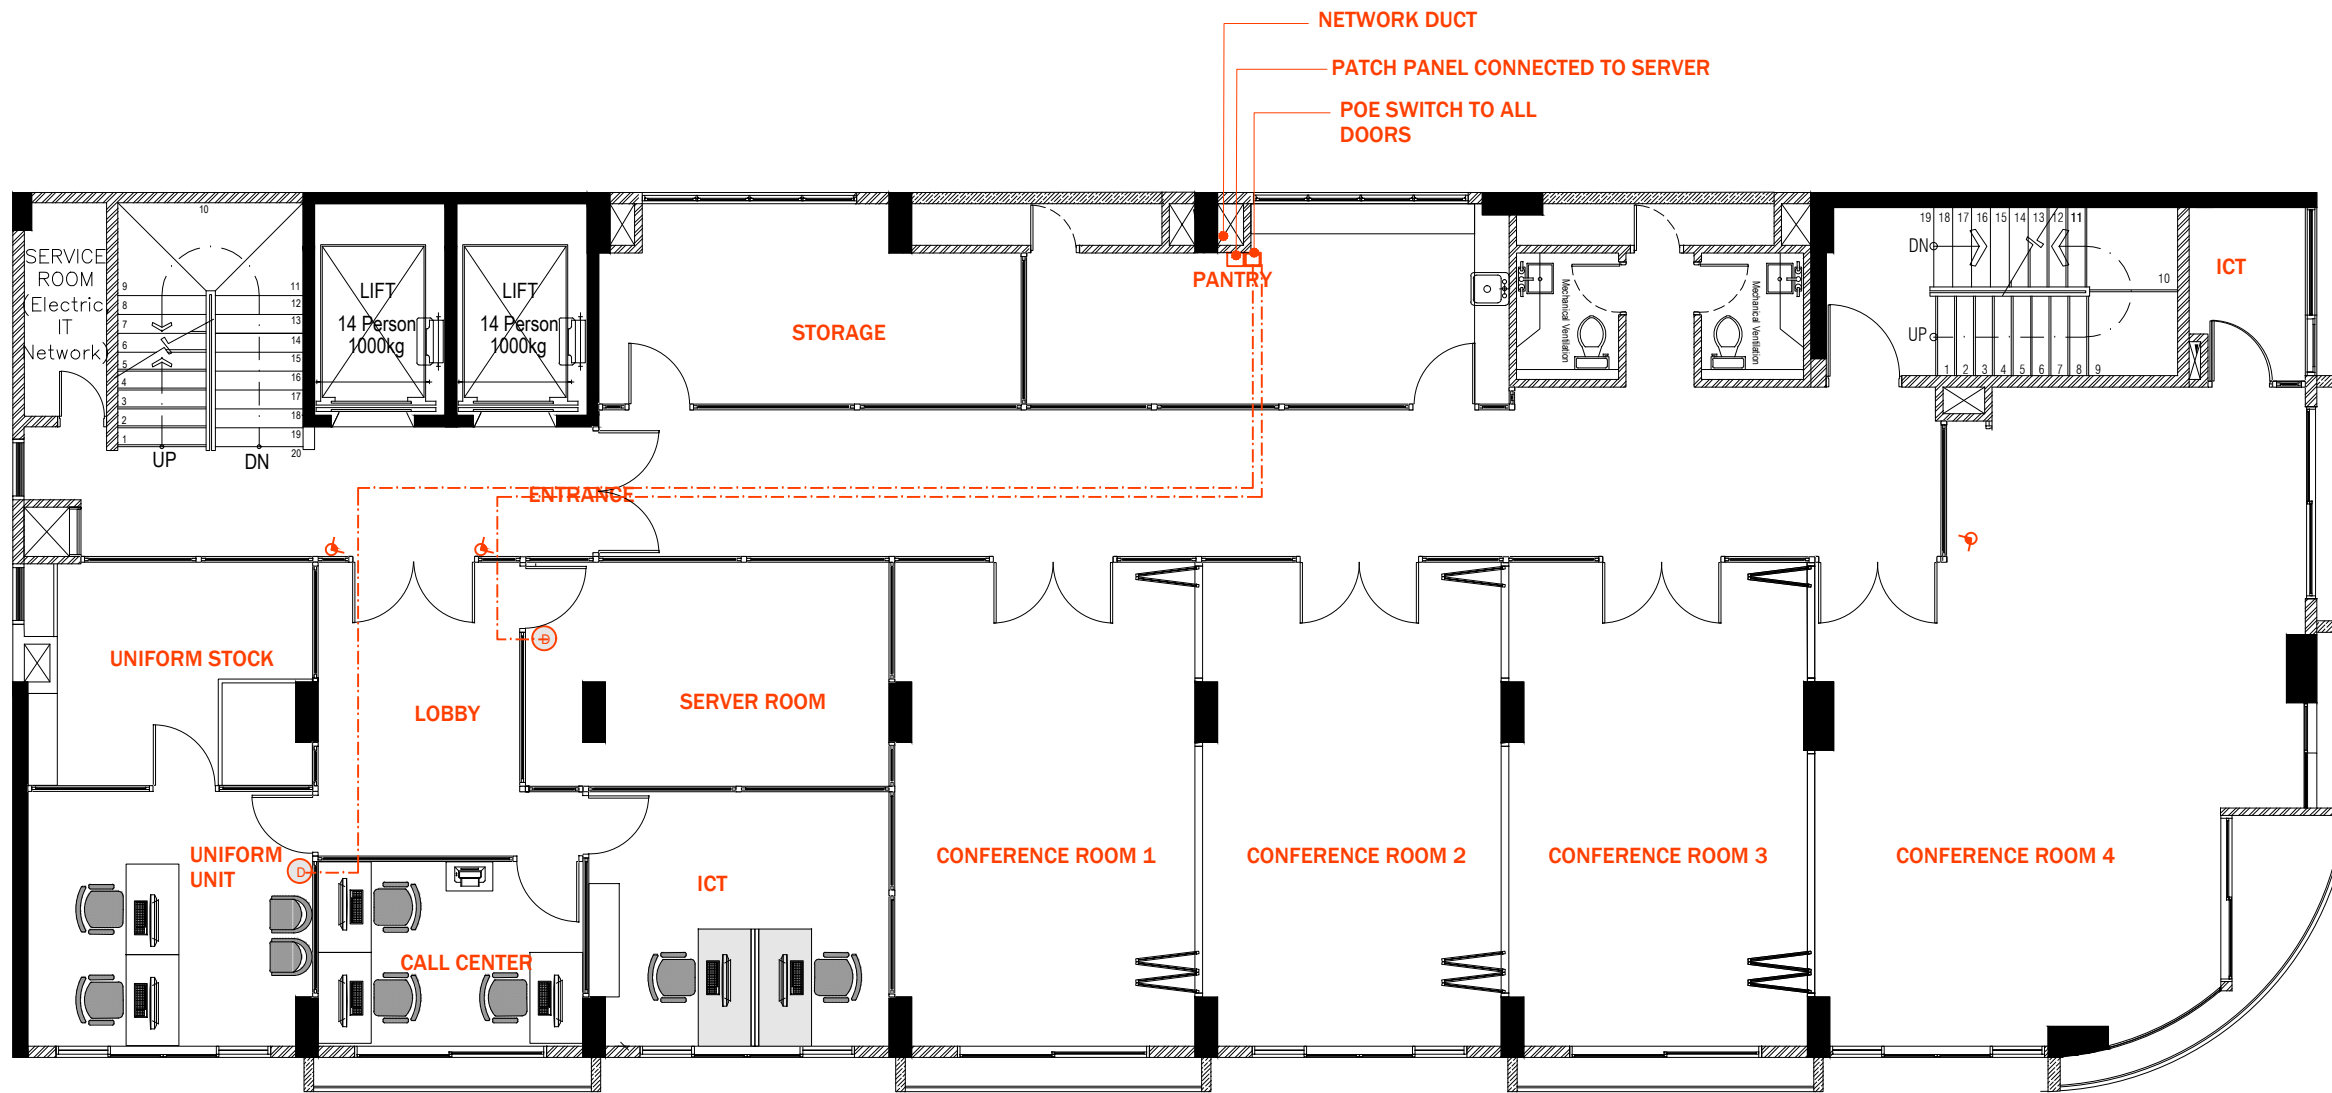

11TH FLOOR NETWORK CABLE , DOOR LOCK AND CCTV LAYOUT
SCALE 1:100



LEGEND	
SYMBOL	DESCRIPTION
	DOOR LOCK
	CCTV CAMERA
	CAT6 CABLE

- IMPORTANT:
- ALL CAMERA TO BE CONNECTED TO SERVER ROOM
 - ALL NETWORK POINTS TO BE CONNECTED TO SERVER ROOM
 - ALL NETWORK POINTS FROM WORK STATIONS TO BE CONNECTED TO THE SERVER ROOM

SHIYARCH

No.	Revision	Checked By	Date

Project Title:
**IMMIGRATION OFFICE
(AT STAR CLOUD BUILDING)**


Client:
MALDIVES IMMIGRATION

Interior Design

Drawing Title:
SITE PLAN

Architect: -	Interior Designer: -
Drawn By: SHIYA	Checked By: -
Paper: A3	Project No: -
Date: FEBRUARY 2021	Scale: AS GIVEN
Drawing No: D-01 /01	

Copyright: The concept and design in this drawing are the properties of shiyarch. unauthorized use of any kind or copying of whole or part of this drawing, concept or design or use on projects or sites other than specified on this drawing is prohibited and apply as terms and conditions under which the client is entitled to use the concept or design in this drawing.

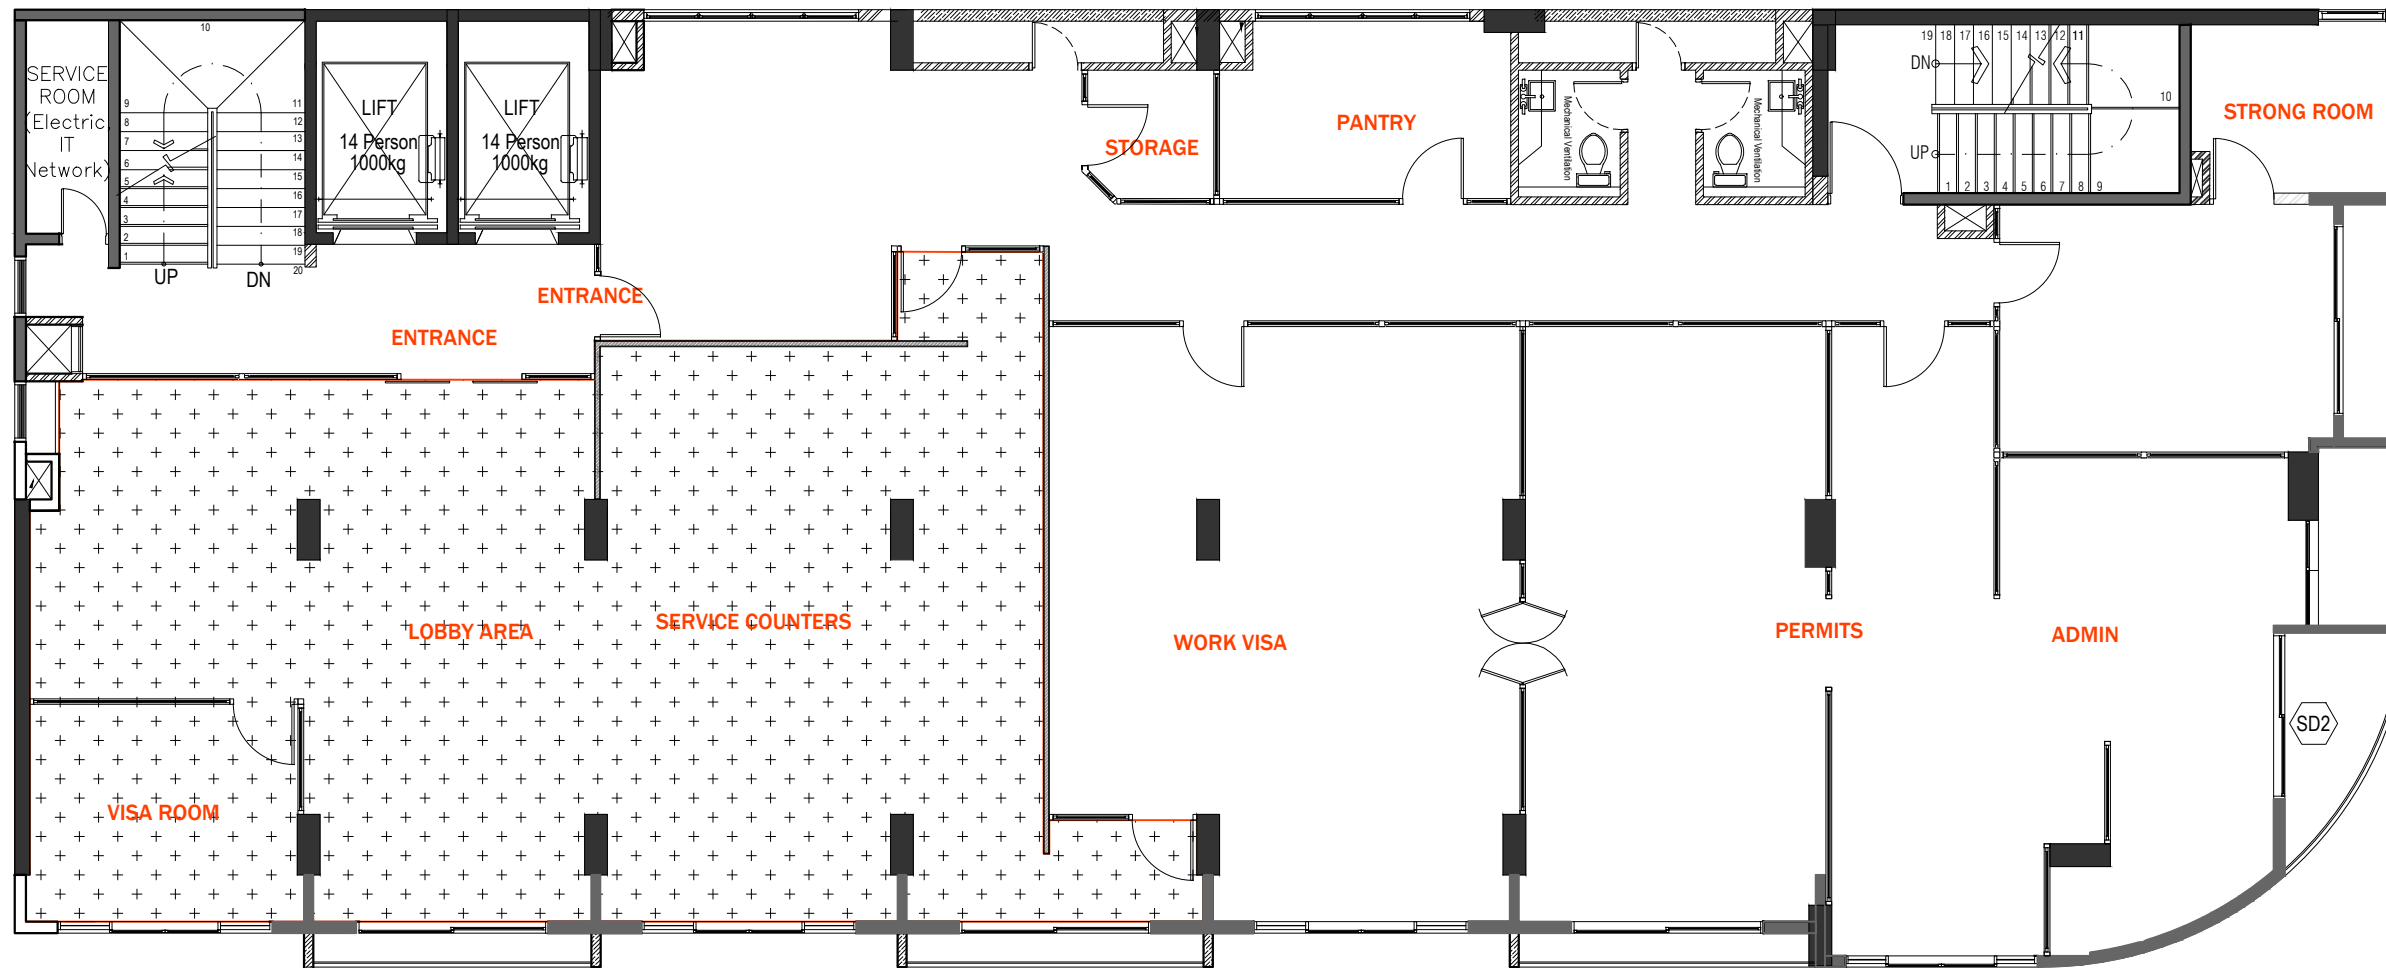

8TH FLOOR FINISH LAYOUT

SCALE 1:100



FLOOR FINISH LEGEND

SYMBOL	DESCRIPTION
	600X600 CARPET TILES
	RAISED FLOOR SYSTEM

NOTE:

- ALL THE MATERIAL TO BE CHECKED AND APPROVED BY THE CONSULTANT / CLIENT
- UNLESS SPECIFIED ALL AREAS TO REMAIN WITH EXISTING TILE
- CARPET TILE DESIGN TO BE SUBMITTED TO CLIENT / CONSULTANT FOR APPROVAL



No.	Revision	Checked By	Date

Project Title:

**IMMIGRATION OFFICE
(AT STAR CLOUD BUILDING)**

Client:


MALDIVES IMMIGRATION

INTERIOR DESIGN

Drawing Title:
SITE PLAN

Architect:	Interior Designer:
SHIYA	
Drawn By:	Checked By:
Paper:	Project No.:
A3	
Date:	Scale:
FEBRUARY 2021	AS GIVEN
Drawing No.:	D-01 /01

Copyright: The concept and design in this drawing are the properties of shiyarch. unauthorized use of any kind or copying of whole or part of this drawing, concept or design or use on projects or sites other than specified on this drawing is prohibited and apply as terms and conditions under which the client is entitled to use the concept or design in this drawing.

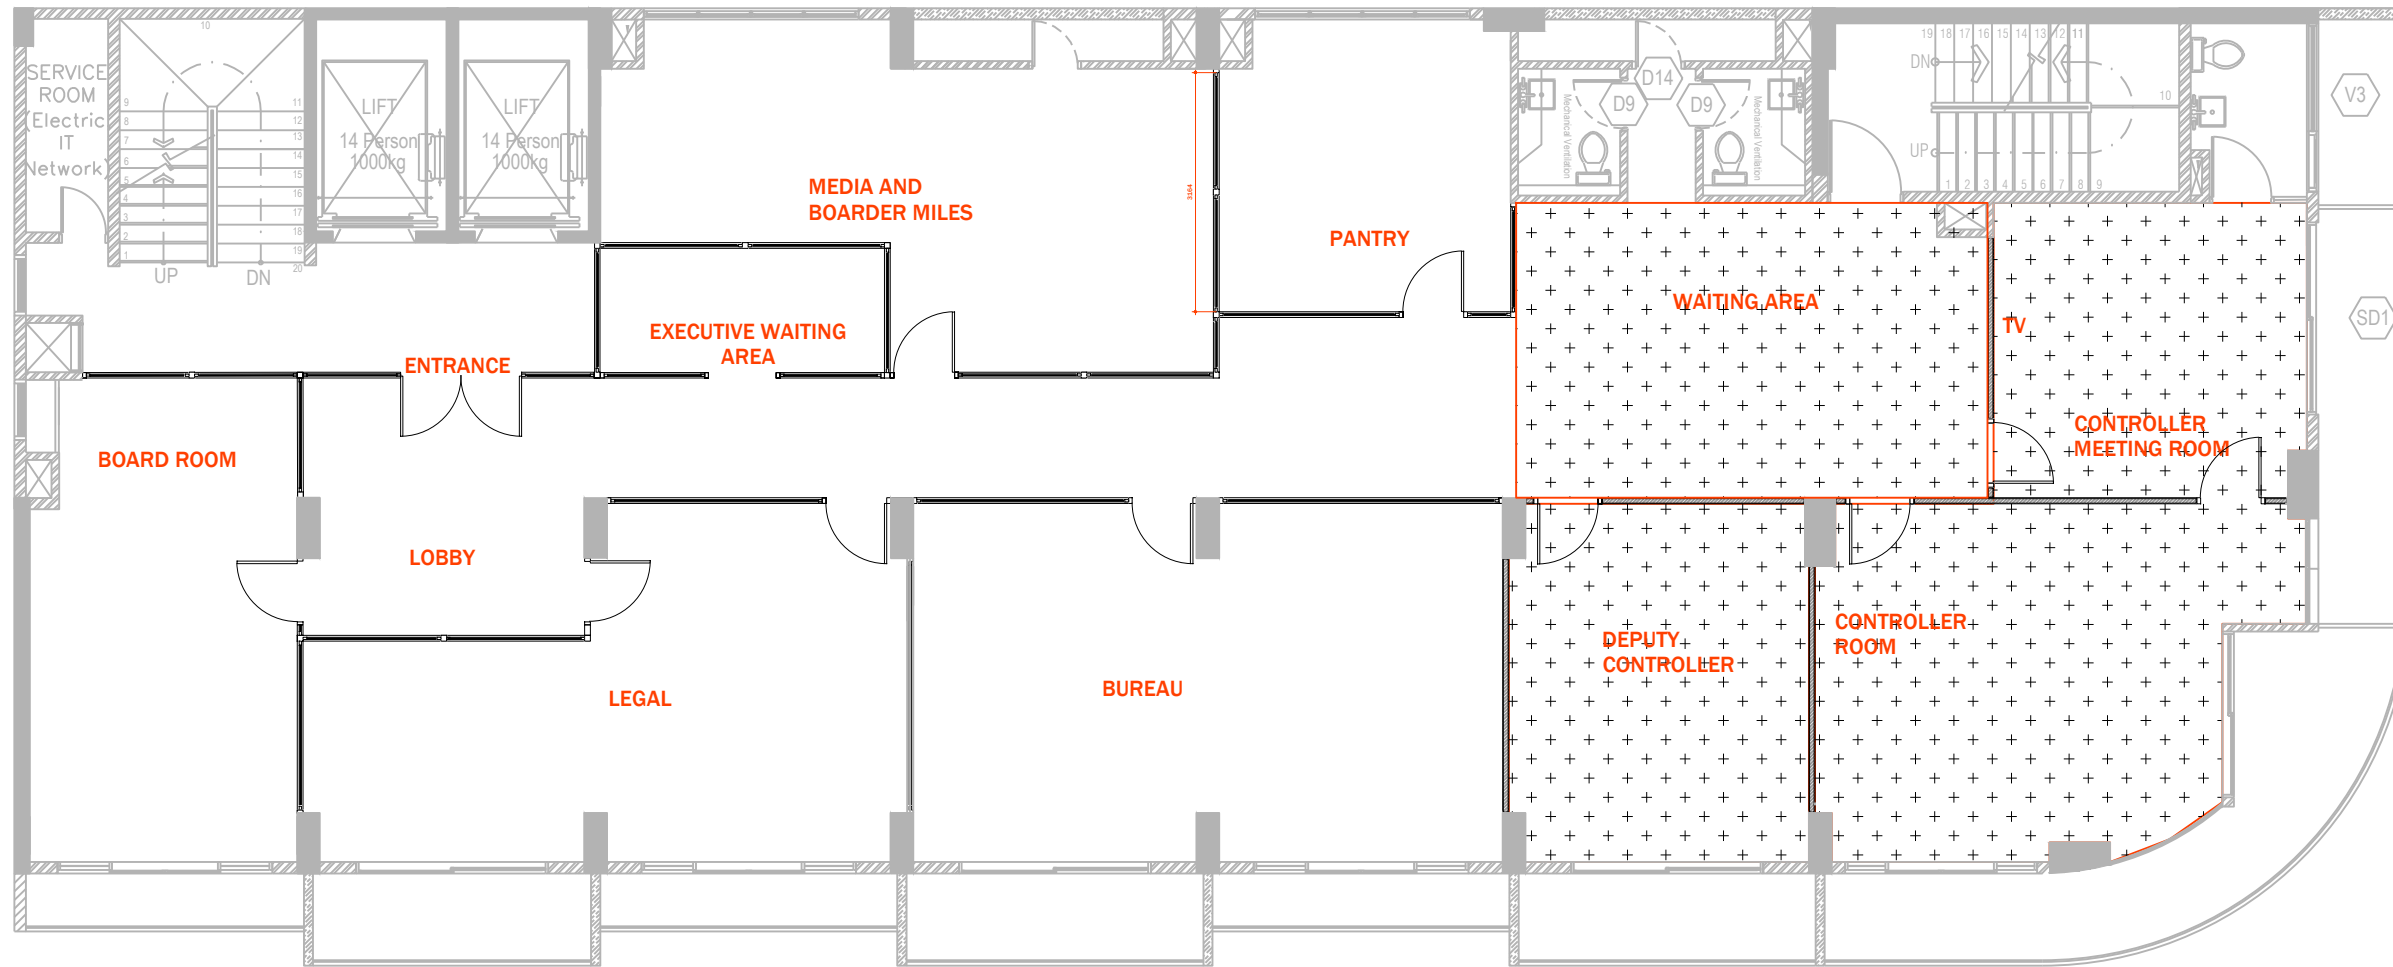

9TH FLOOR FINISH LAYOUT

SCALE 1:100



FLOOR FINISH LEGEND

SYMBOL	DESCRIPTION
	600X600 CARPET TILES
	RAISED FLOOR SYSTEM

NOTE:

- ALL THE MATERIAL TO BE CHECKED AND APPROVED BY THE CONSULTANT / CLIENT
- UNLESS SPECIFIED ALL AREAS TO REMAIN WITH EXISTING TILE
- CARPET TILE DESIGN TO BE SUBMITTED TO CLIENT / CONSULTANT FOR APPROVAL

SHIYARCH

No.	Revision	Checked By	Date

Project Title:
**IMMIGRATION OFFICE
(AT STAR CLOUD BUILDING)**


Client:
MALDIVES IMMIGRATION

INTERIOR DESIGN

Drawing Title:
SITE PLAN

Architect: -	Interior Designer: -
Drawn By: SHIYA	Checked By: -
Paper: A3	Project No: -
Date: FEBRUARY 2021	Scale: AS GIVEN
Drawing No: D-01 /01	

Copyright: The concept and design in this drawing are the properties of shiyarch. unauthorized use of any kind or copying of whole or part of this drawing, concept or design or use on projects or sites other than specified on this drawing is prohibited and apply as terms and conditions under which the client is entitled to use the concept or design in this drawing.

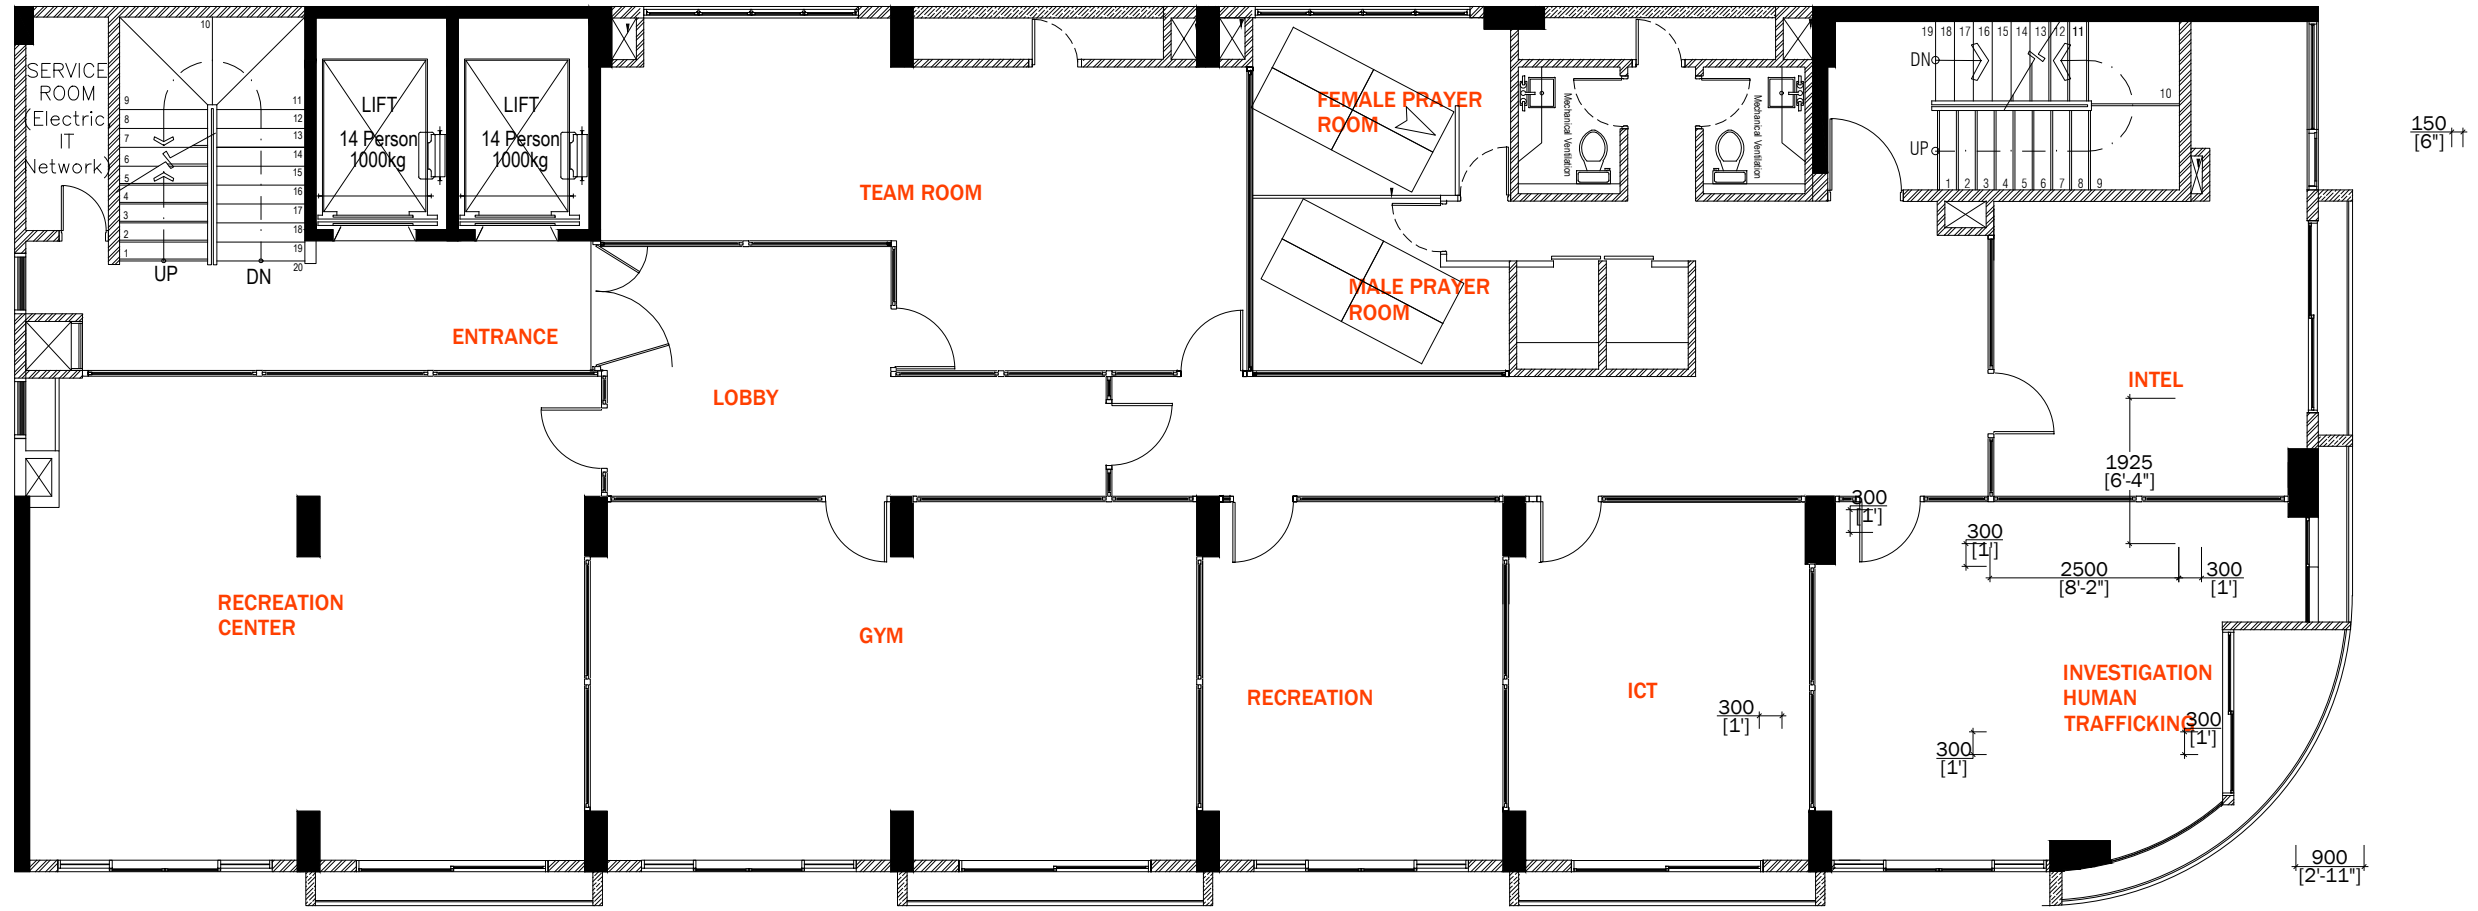

10TH FLOOR FINISH LAYOUT
SCALE 1:100

FLOOR FINISH LEGEND

SYMBOL	DESCRIPTION
	600X600 CARPET TILES
	RAISED FLOOR SYSTEM

NOTE:

- ALL THE MATERIAL TO BE CHECKED AND APPROVED BY THE CONSULTANT / CLIENT
- UNLESS SPECIFIED ALL AREAS TO REMAIN WITH EXISTING TILE
- CARPET TILE DESIGN TO BE SUBMITTED TO CLIENT / CONSULTANT FOR APPROVAL



No.	Revision	Checked By	Date

Project Title:
**IMMIGRATION OFFICE
(AT STAR CLOUD BUILDING)**


Client:
MALDIVES IMMIGRATION

INTERIOR DESIGN

Drawing Title:
SITE PLAN

Architect: -	Interior Designer: -
Drawn By: SHIYA	Checked By: -
Paper: A3	Project No: -
Date: FEBRUARY 2021	Scale: AS GIVEN
Drawing No: D-01 /01	

Copyright: The concept and design in this drawing are the properties of shiyarch. unauthorized use of any kind or copying of whole or part of this drawing, concept or design or use on projects or sites other than specified on this drawing is prohibited and apply as terms and conditions under which the client is entitled to use the concept or design in this drawing.

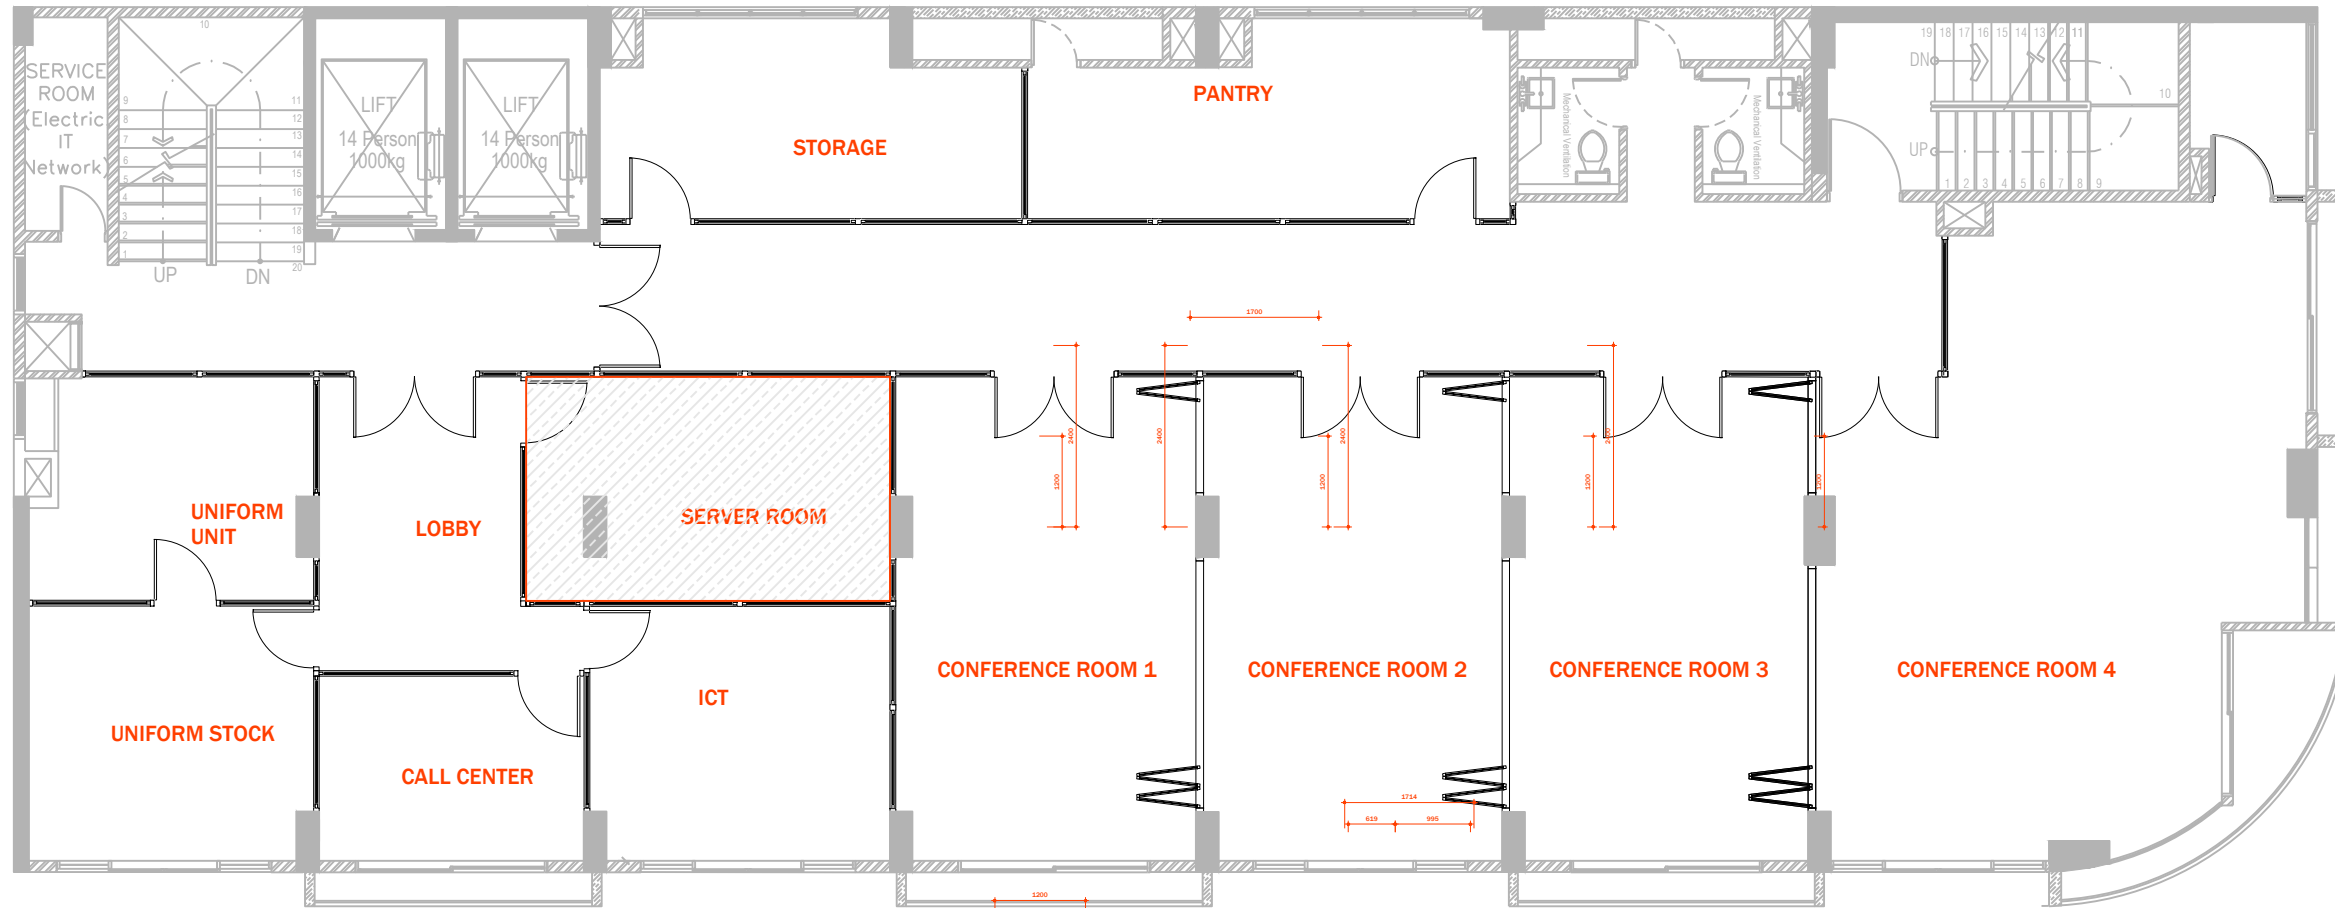

11TH FLOOR FINISH LAYOUT

SCALE 1:100



FLOOR FINISH LEGEND

SYMBOL	DESCRIPTION
	600X600 CARPET TILES
	RAISED FLOOR SYSTEM

NOTE:

- ALL THE MATERIAL TO BE CHECKED AND APPROVED BY THE CONSULTANT / CLIENT
- UNLESS SPECIFIED ALL AREAS TO REMAIN WITH EXISTING TILE
- CARPET TILE DESIGN TO BE SUBMITTED TO CLIENT / CONSULTANT FOR APPROVAL

REFERENCE IMAGE



SHIYARCH

No.	Revision	Checked By	Date

Project Title:
**IMMIGRATION OFFICE
(AT STAR CLOUD BUILDING)**

Client:
MALDIVES IMMIGRATION




INTERIOR DESIGN

Drawing Title:
SITE PLAN


Architect: -	Interior Designer: -
Drawn By: SHIYA	Checked By: -
Paper: A3	Project No: -
Date: FEBRUARY 2021	Scale: AS GIVEN
Drawing No: D-01 /01	

Copyright: The concept and design in this drawing are the properties of shiyarch. unauthorized use of any kind or copying of whole or part of this drawing, concept or design or use on projects or sites other than specified on this drawing is prohibited and apply as terms and conditions under which the client is entitled to use the concept or design in this drawing.

COUNTER DETAIL (F2)

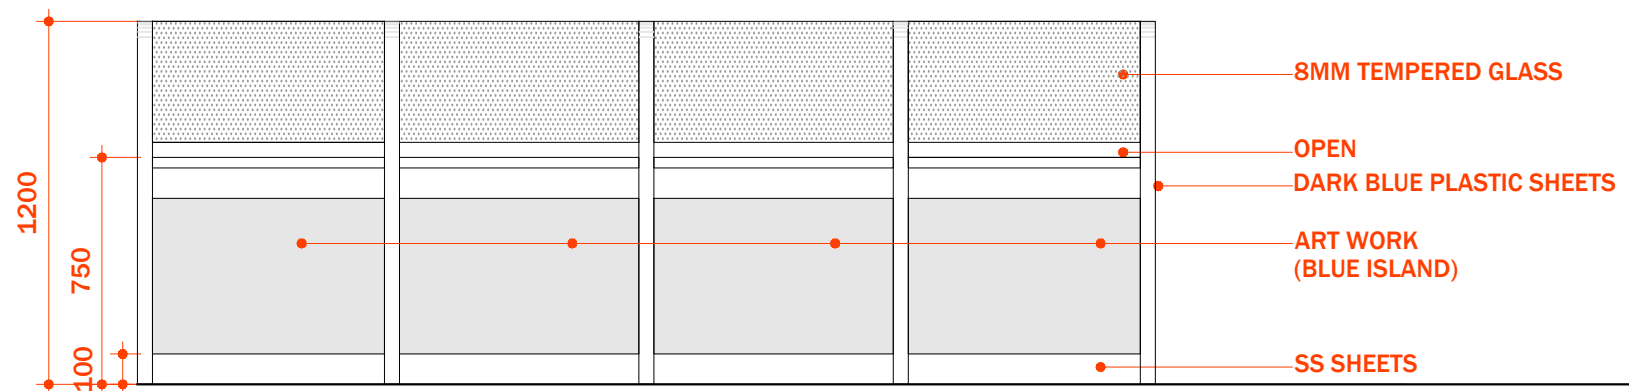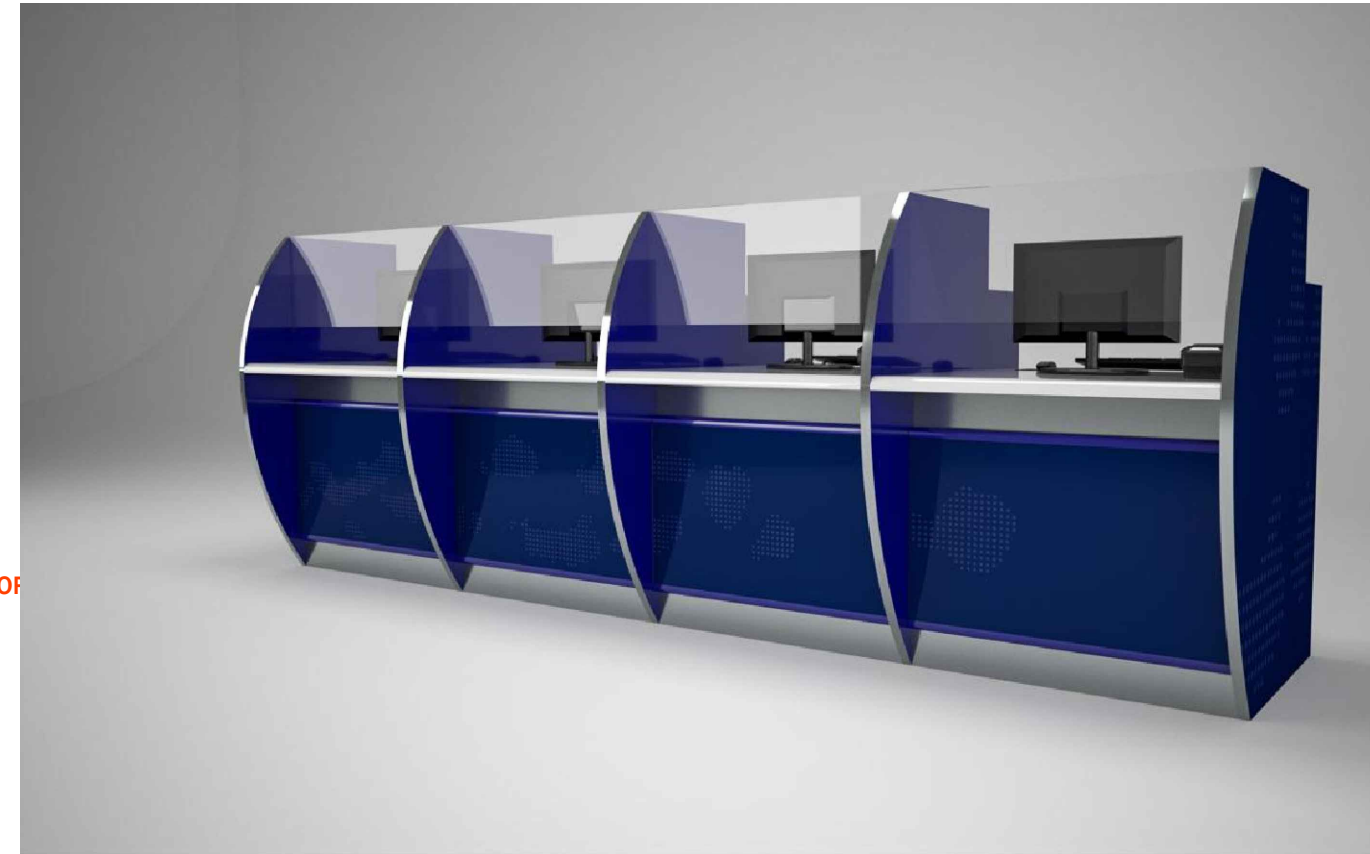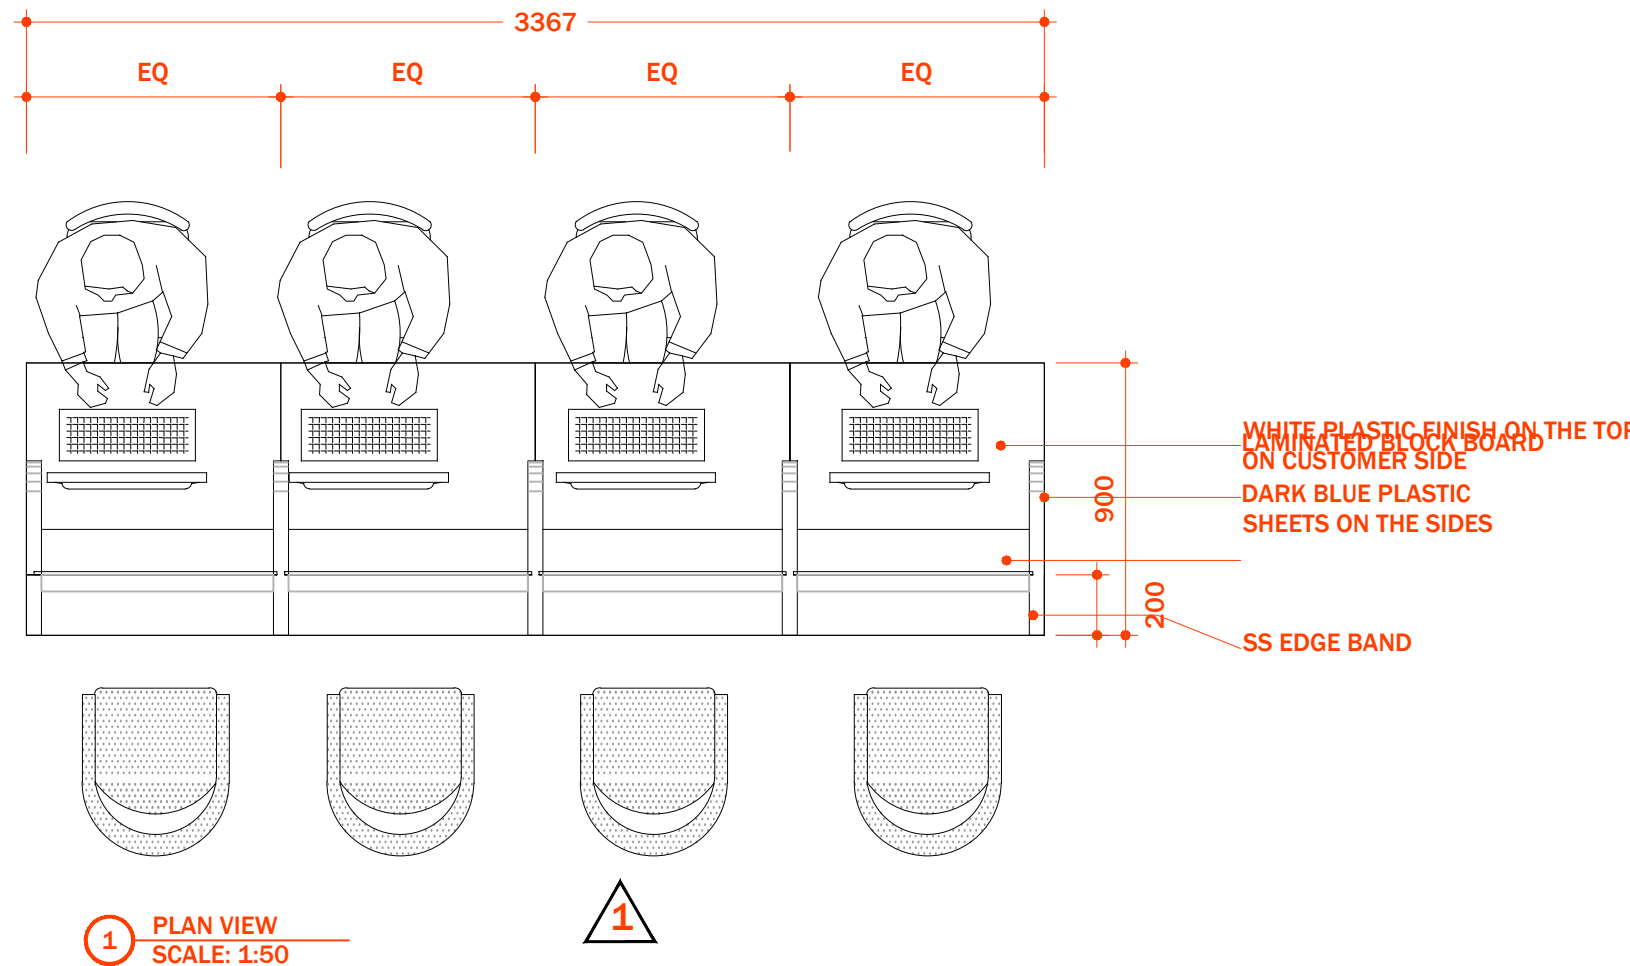

1 ELEVATION 1 SCALE: 1:30

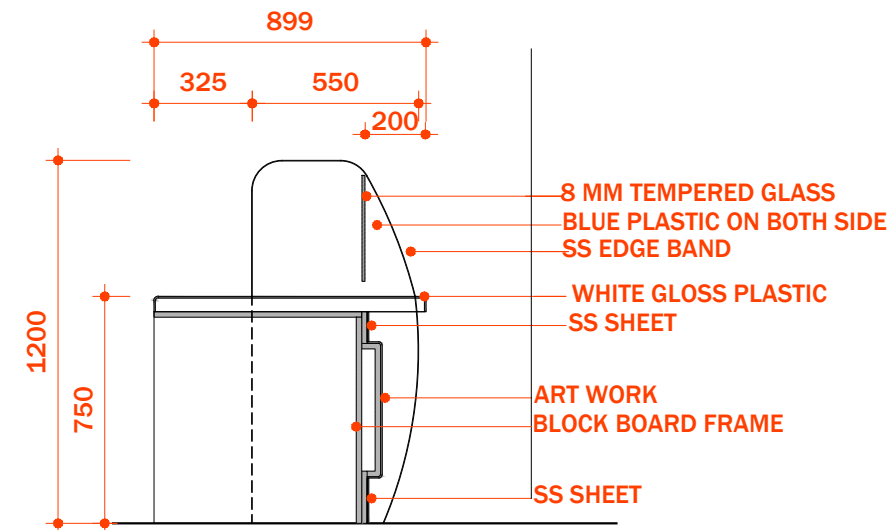

1 SECTION 1 SCALE: 1:25

SHIYARCH

No.	Revision	Checked By	Date

Project Title:
IMMIGRATION OFFICE
(AT STAR CLOUD BUILDING)

Client:
MALDIVES IMMIGRATION


INTERIOR DESIGN

Drawing Title:
SITE PLAN


Architect: SHIYA	Interior Designer: -
Drawn By: SHIYA	Checked By: -
Paper: A3	Project No: -
Date: FEBRUARY 2021	Scale: AS GIVEN

Drawing No:
D-01 /01



Copyright: The concept and design in this drawing are the properties of shiyarch. unauthorized use of any kind or copying of whole or part of this drawing, concept or design or use on projects or sites other than specified on this drawing is prohibited and apply as terms and conditions under which the client is entitled to use the concept or design in this drawing.

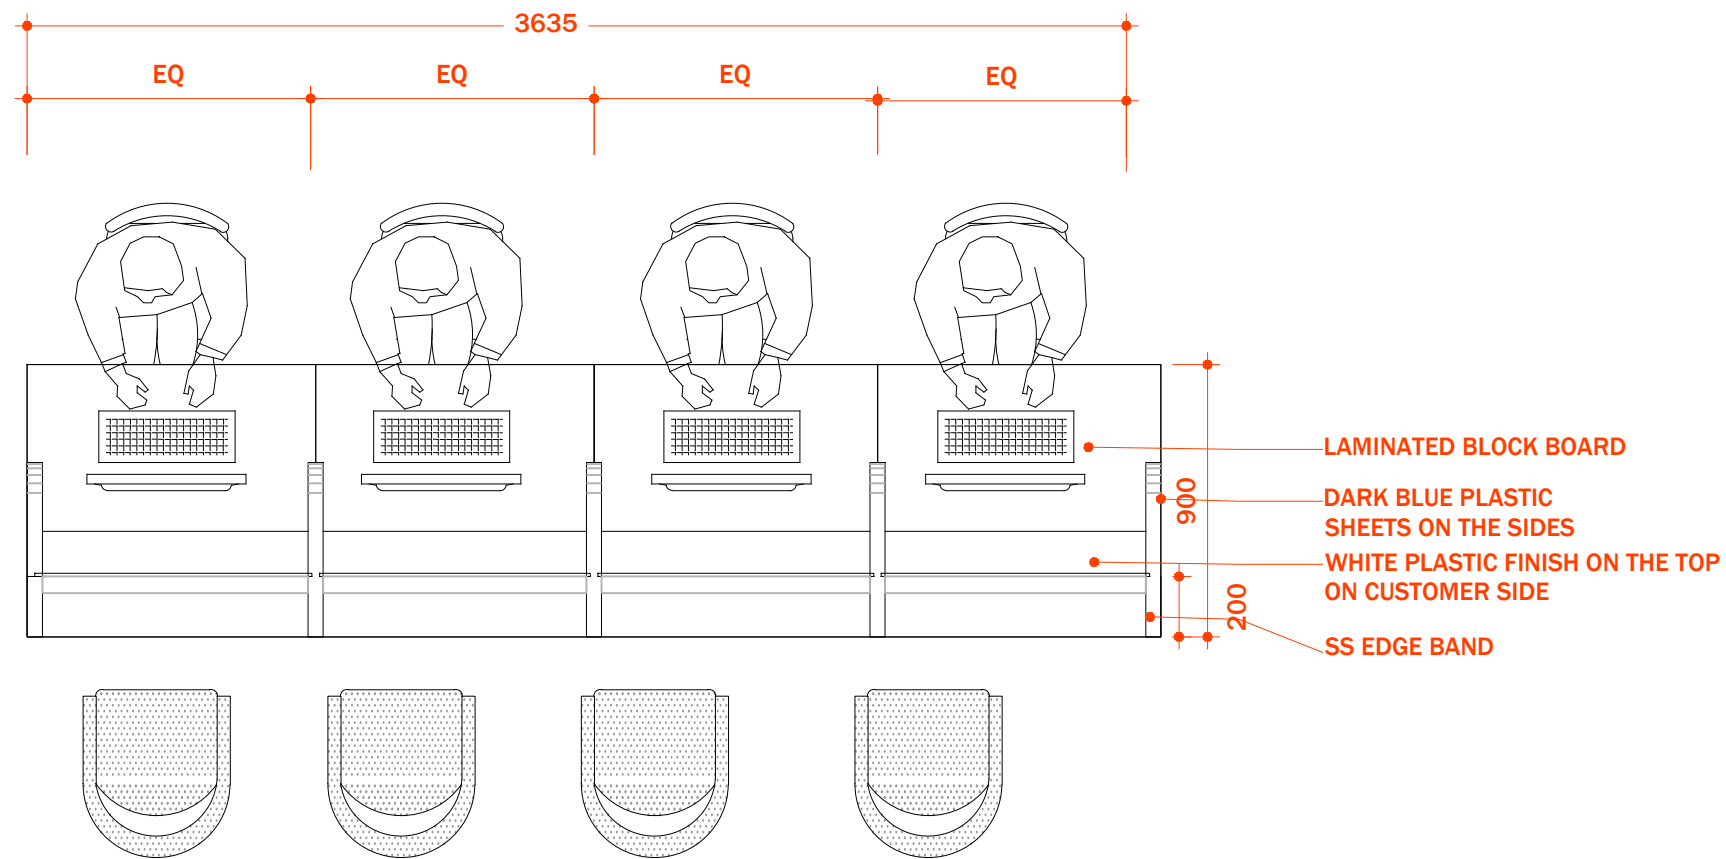

1 PLAN VIEW
SCALE: 1:50

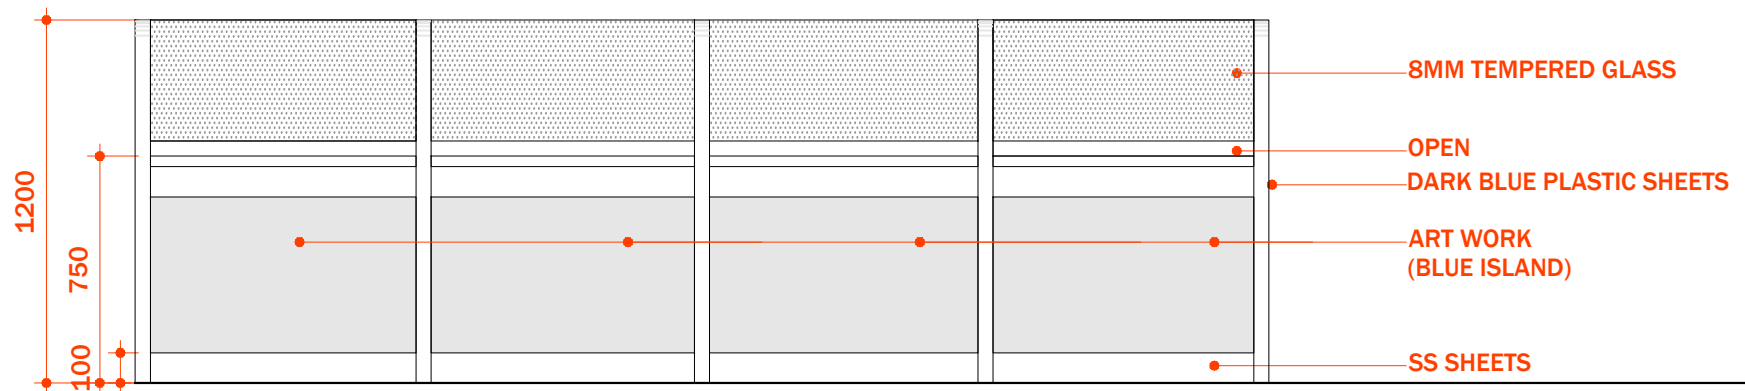

1 ELEVATION 1
SCALE: 1:30

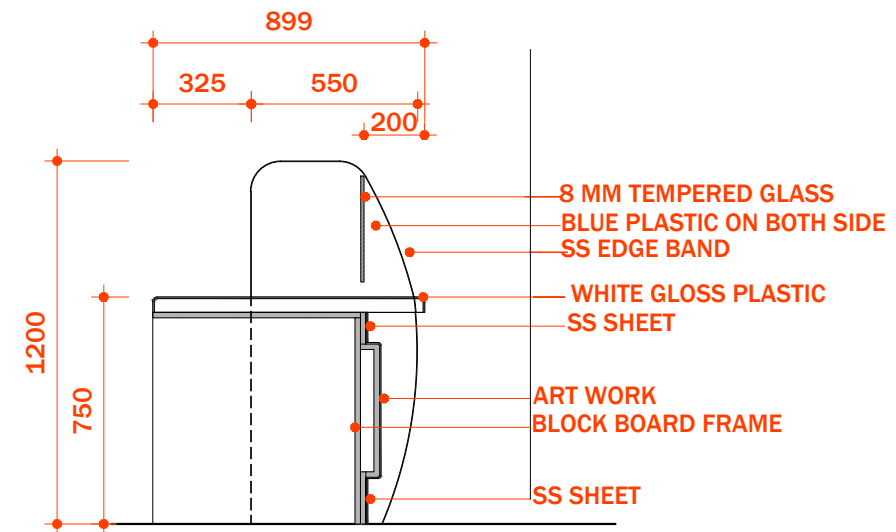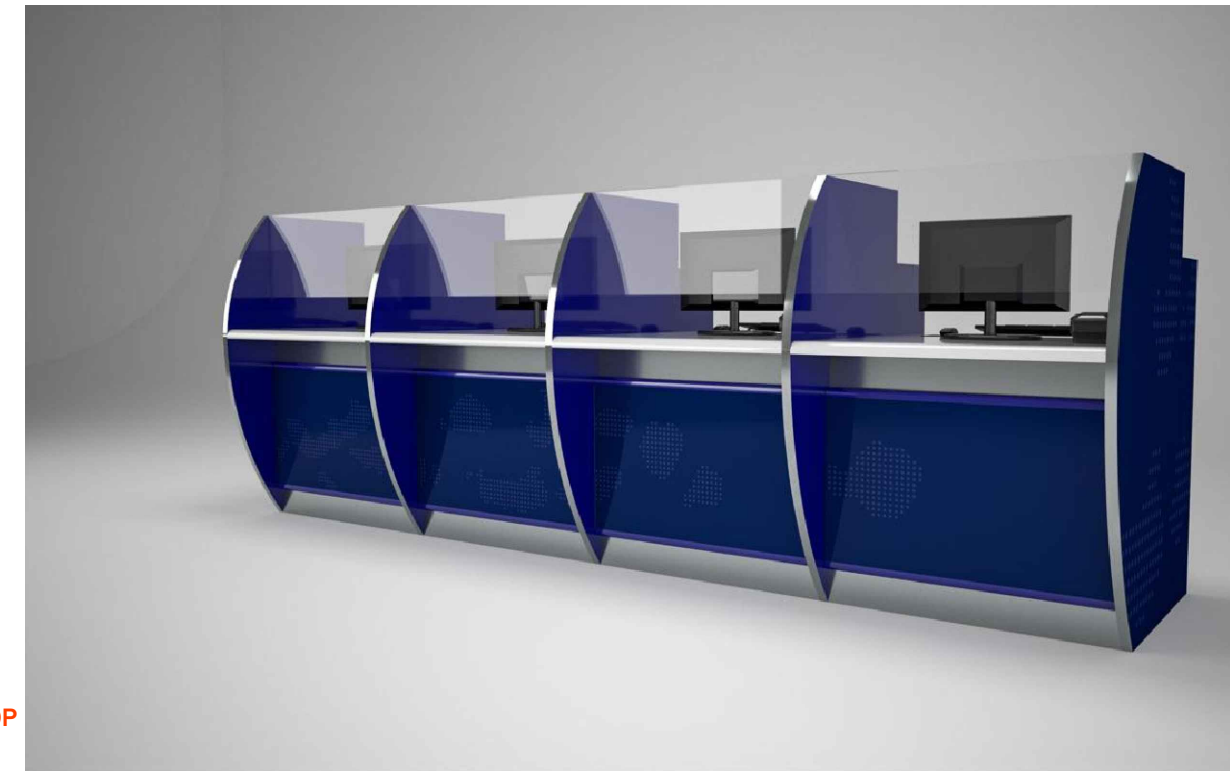

1 SECTION 1
SCALE: 1:25

SHIYARCH

No.	Revision	Checked By	Date

Project Title:
IMMIGRATION OFFICE
(AT STAR CLOUD BUILDING)

Client:
MALDIVES IMMIGRATION


INTERIOR DESIGN

Drawing Title:
SITE PLAN

Architect: SHIYA	Interior Designer: -
Drawn By: SHIYA	Checked By: -
Paper: A3	Project No: -
Date: FEBRUARY 2021	Scale: AS GIVEN

Drawing No:
D-01 /01

Copyright: The concept and design in this drawing are the properties of shiyarch. unauthorized use of any kind or copying of whole or part of this drawing, concept or design or use on projects or sites other than specified on this drawing is prohibited and apply as terms and conditions under which the client is entitled to use the concept or design in this drawing.

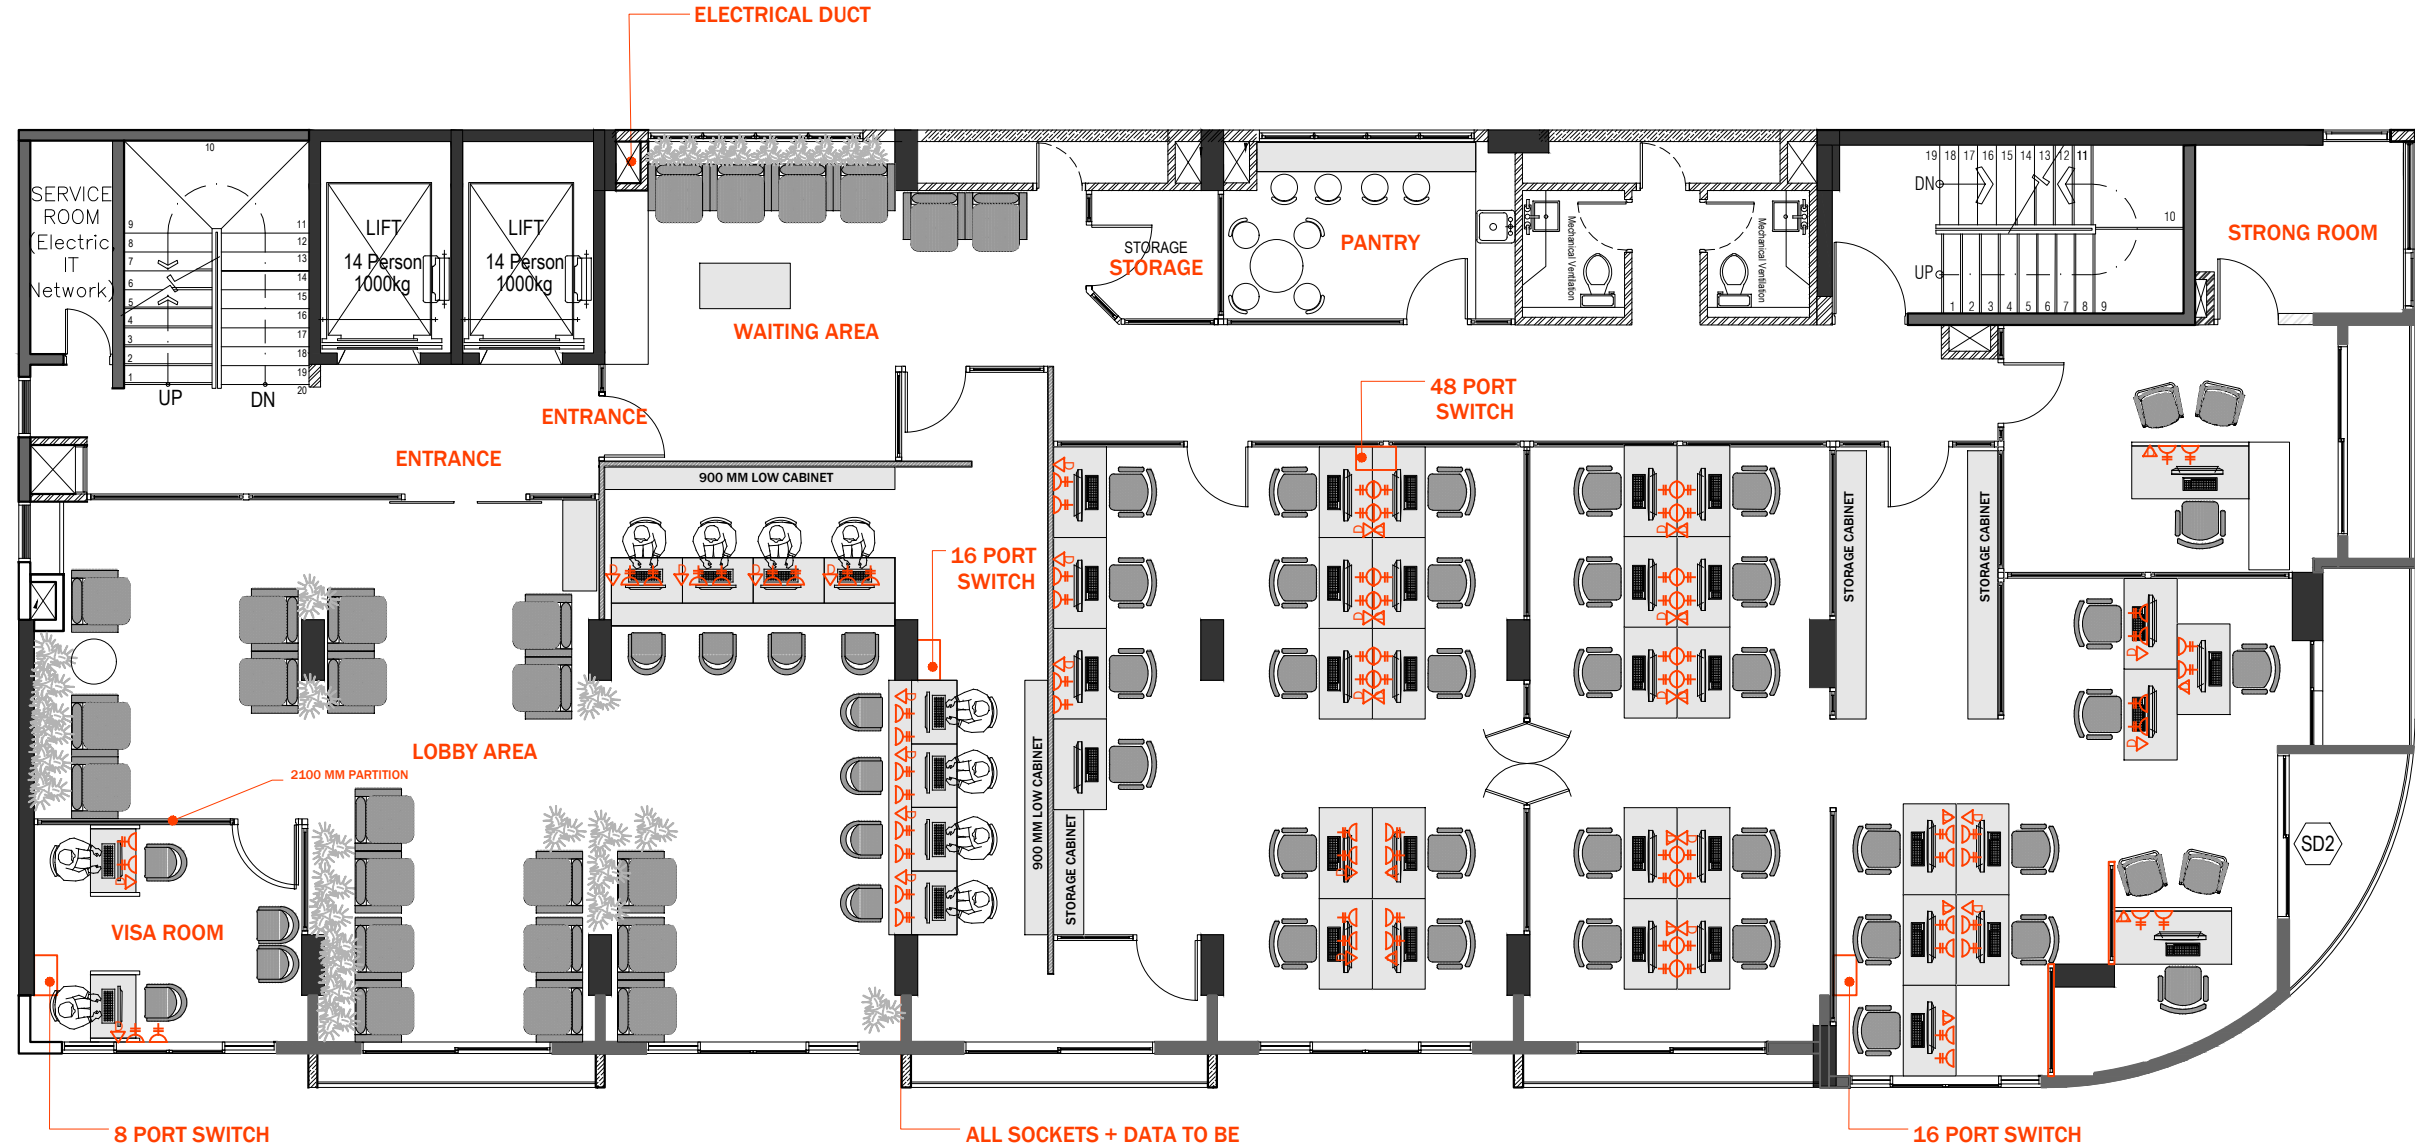

8TH FLOOR ELECTRICAL LAYOUT
SCALE 1:100



ALL SOCKETS + DATA TO BE FIXED UNDER THE COURTERS

SYMBOL	DESCRIPTION
⚡15A	15AMP X 1 GANG POWER SOCKET
⚡	13AMP X 1 GANG POWER SOCKET
⚡2	13AMP X 2 GANG POWER SOCKET
⚡C	15AMP X 1 GANG POWER SOCKET @ CEILING LVL
⚡P	SINGLE PHASE WITH ISOLATOR GANG POWER SOCKET
⚡3P	3 PHASE WITH ISOLATOR GANG POWER SOCKET
⚡WP	IP65 WEATHER PROOF POWER SOCKET
📶	DATA SOCKET (RJ45)
🧐	SHAVER SOCKET
☎	TELEPHONE SOCKET (RJ11)
📶	WIFI AMPLIFIER REPEATER
📺	TV SOCKET

- IMPORTANT:**
- ALL GIVEN HEIGHTS ARE FROM FINISHED FLOOR LEVEL
 - ALL SWITCHES AT 1.2M HEIGHT ABOVE FINISHED FLOOR LEVEL EXCEPT WHERE SPECIFIED
 - ALL SOCKETS AT 0.3M HEIGHT ABOVE FINISHED FLOOR LEVEL EXCEPT WHERE SPECIFIED
 - UNLESS SPECIFIED OTHERWISE ALL LIGHT SWITCHES AND FAN DIMMERS AT BED SIDE ARE AT 0.75M FROM FLOOR FINISH LEVEL.
 - SELECTED LIGHTING FIXTURE TO BE APPROVED BY CLIENT / ID
 - SELECTED SWITCHES AND SOCKETS TO BE APPROVED BY CLIENT / ID
 - UNLESS SPECIFIED OTHERWISE ALL LED LIGHTS ARE @ CILLING LVL
 - ALL COCKETS FOR THE WORK STATION TO BE FIXED ON PER THE DESK



No.	Revision	Checked By	Date

Project Title:
**IMMIGRATION OFFICE
(AT STAR CLOUD BUILDING)**


Client:
MALDIVES IMMIGRATION

INTERIOR DESIGN

Drawing Title:
SITE PLAN


Architect: -	Interior Designer: -
Drawn By: SHIYA	Checked By: -
Paper: A3	Project No: -
Date: FEBRUARY 2021	Scale: AS GIVEN
Drawing No: D-01 /01	

Copyright: The concept and design in this drawing are the properties of shiyarch. unauthorized use of any kind or copying of whole or part of this drawing, concept or design or use on projects or sites other than specified on this drawing is prohibited and apply as terms and conditions under which the client is entitled to use the concept or design in this drawing.

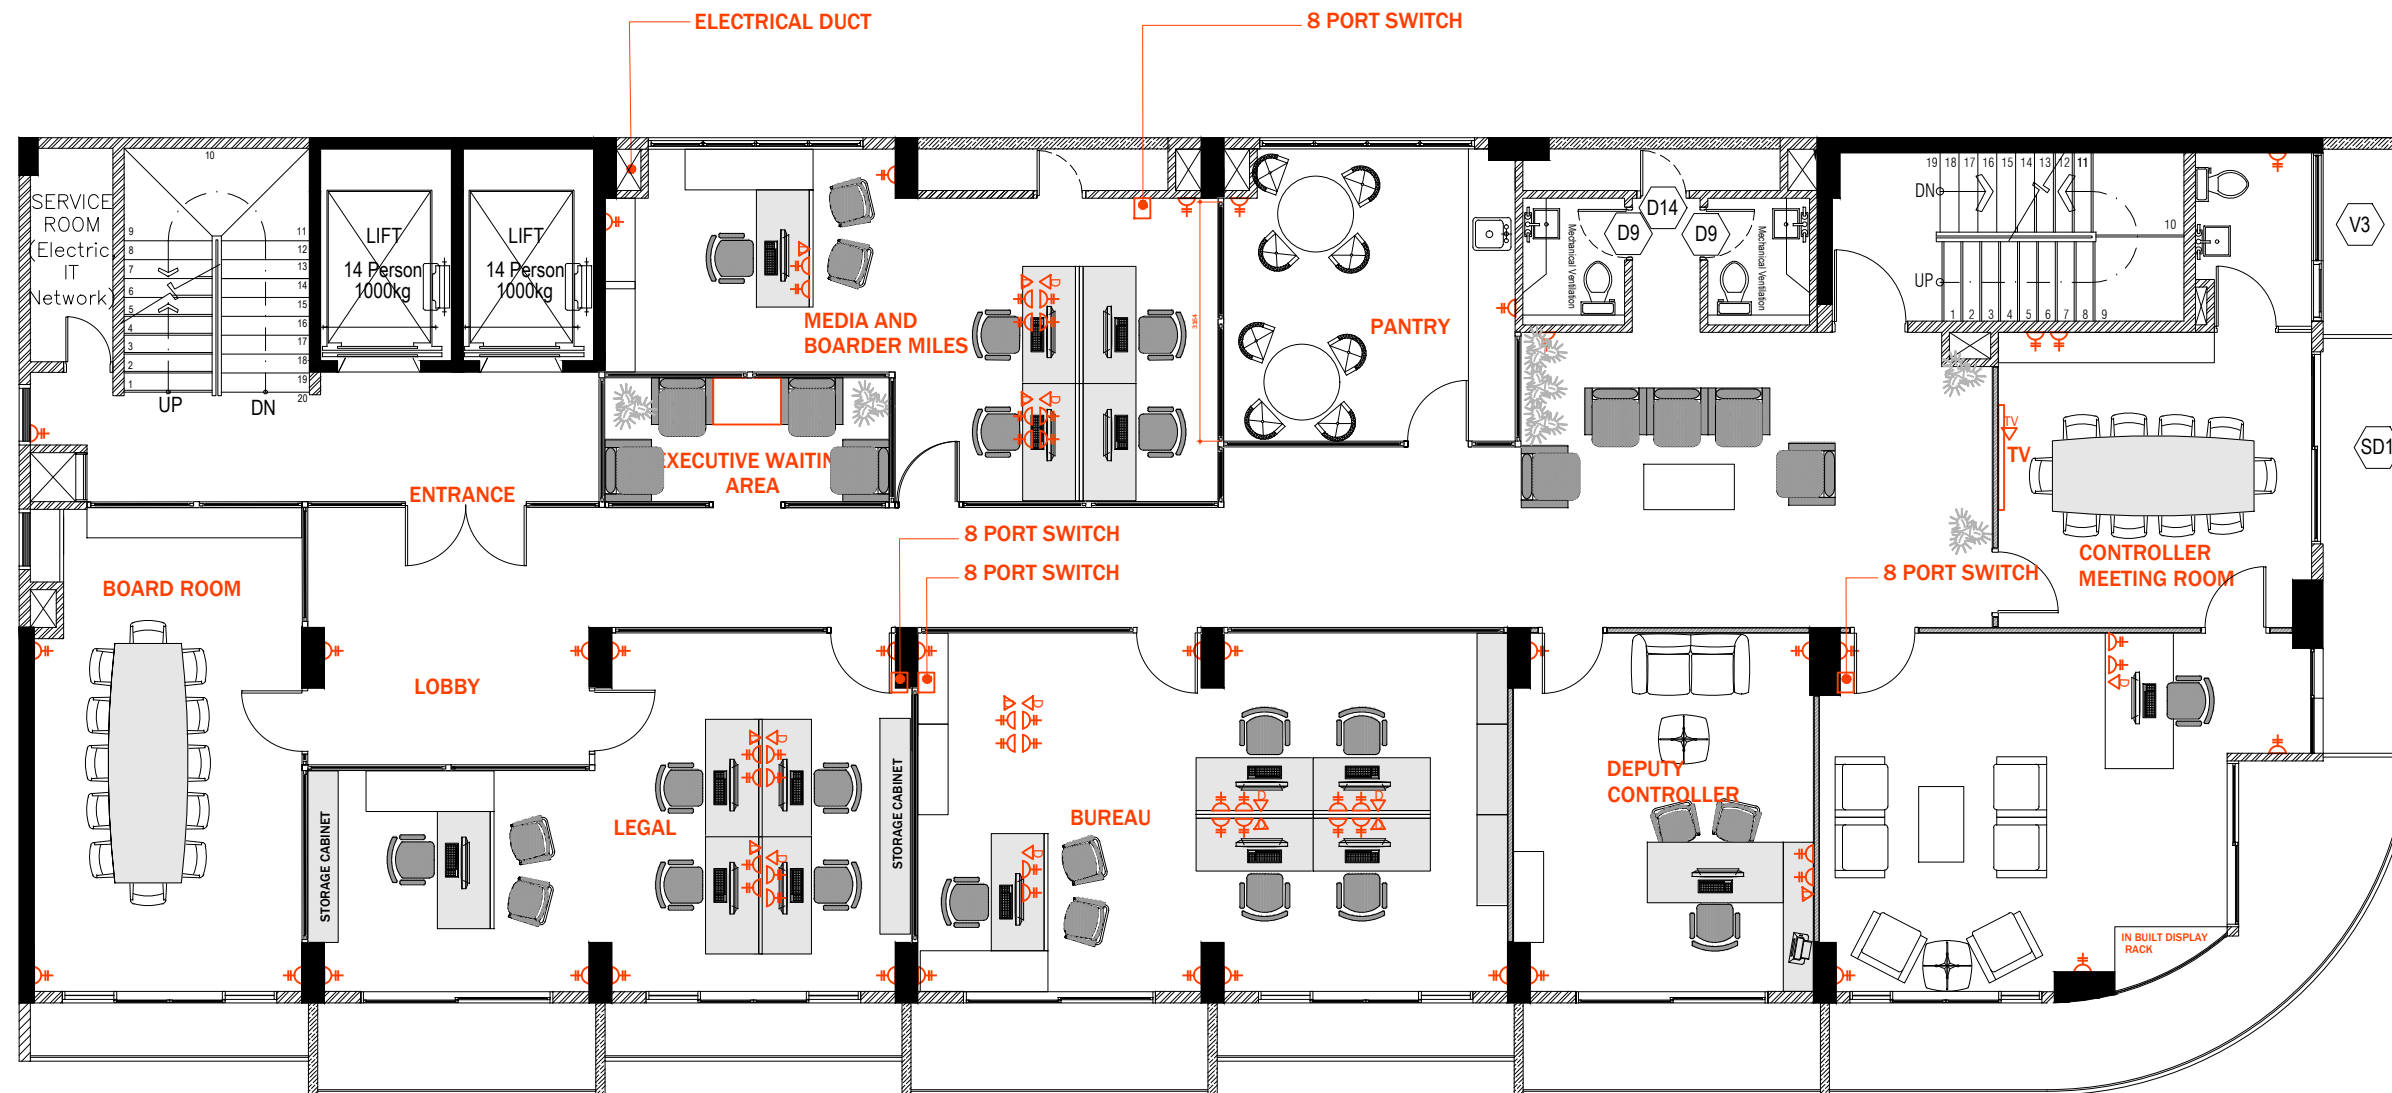

9TH FLOOR ELECTRICAL LAYOUT

 SCALE 1:100



ELECTRICAL POWER AND LIGHTING LEGEND

SYMBOL	DESCRIPTION
	15AMP X 1 GANG POWER SOCKET
	13AMP X 1 GANG POWER SOCKET
	13AMP X 2 GANG POWER SOCKET
	15AMP X 1 GANG POWER SOCKET @ CEILING LVL
	SINGLE PHASE WITH ISOLATOR GANG POWER SOCKET
	3 PHASE WITH ISOLATOR GANG POWER SOCKET
	IP65 WEATHER PROOF POWER SOCKET
	DATA SOCKET (RJ45)
	SHAVER SOCKET
	TELEPHONE SOCKET (RJ11)
	WIFI AMPLIFIER REPEATER
	TV SOCKET

- IMPORTANT:**
- ALL GIVEN HEIGHTS ARE FROM FINISHED FLOOR LEVEL
 - ALL SWITCHES AT 1.2M HEIGHT ABOVE FINISHED FLOOR LEVEL EXCEPT WHERE SPECIFIED
 - ALL SOCKETS AT 0.3M HEIGHT ABOVE FINISHED FLOOR LEVEL EXCEPT WHERE SPECIFIED
 - UNLESS SPECIFIED OTHERWISE ALL LIGHT SWITCHES AND FAN DIMMERS AT BED SIDE ARE AT 0.75M FROM FLOOR FINISH LEVEL.
 - SELECTED LIGHTING FIXTURE TO BE APPROVED BY CLIENT / ID
 - SELECTED SWITCHES AND SOCKETS TO BE APPROVED BY CLIENT / ID
 - UNLESS SPECIFIED OTHERWISE ALL LED LIGHTS ARE @ CILLING LVL
 - ALL COCKETS FOR THE WORK STATION TO BE FIXED ON PER THE DESK

SHIYARCH

No.	Revision	Checked By	Date

Project Title:

**IMMIGRATION OFFICE
(AT STAR CLOUD BUILDING)**

Client:


MALDIVES IMMIGRATION

INTERIOR DESIGN

Drawing Title:
SITE PLAN

Architect:	Interior Designer:
SHIYA	
Drawn By:	Checked By:
Paper:	Project No.:
A3	
Date:	Scale:
FEBRUARY 2021	AS GIVEN
Drawing No.:	D-01 /01

Copyright: The concept and design in this drawing are the properties of shiyarch. unauthorized use of any kind or copying of whole or part of this drawing, concept or design or use on projects or sites other than specified on this drawing is prohibited and apply as terms and conditions under which the client is entitled to use the concept or design in this drawing.

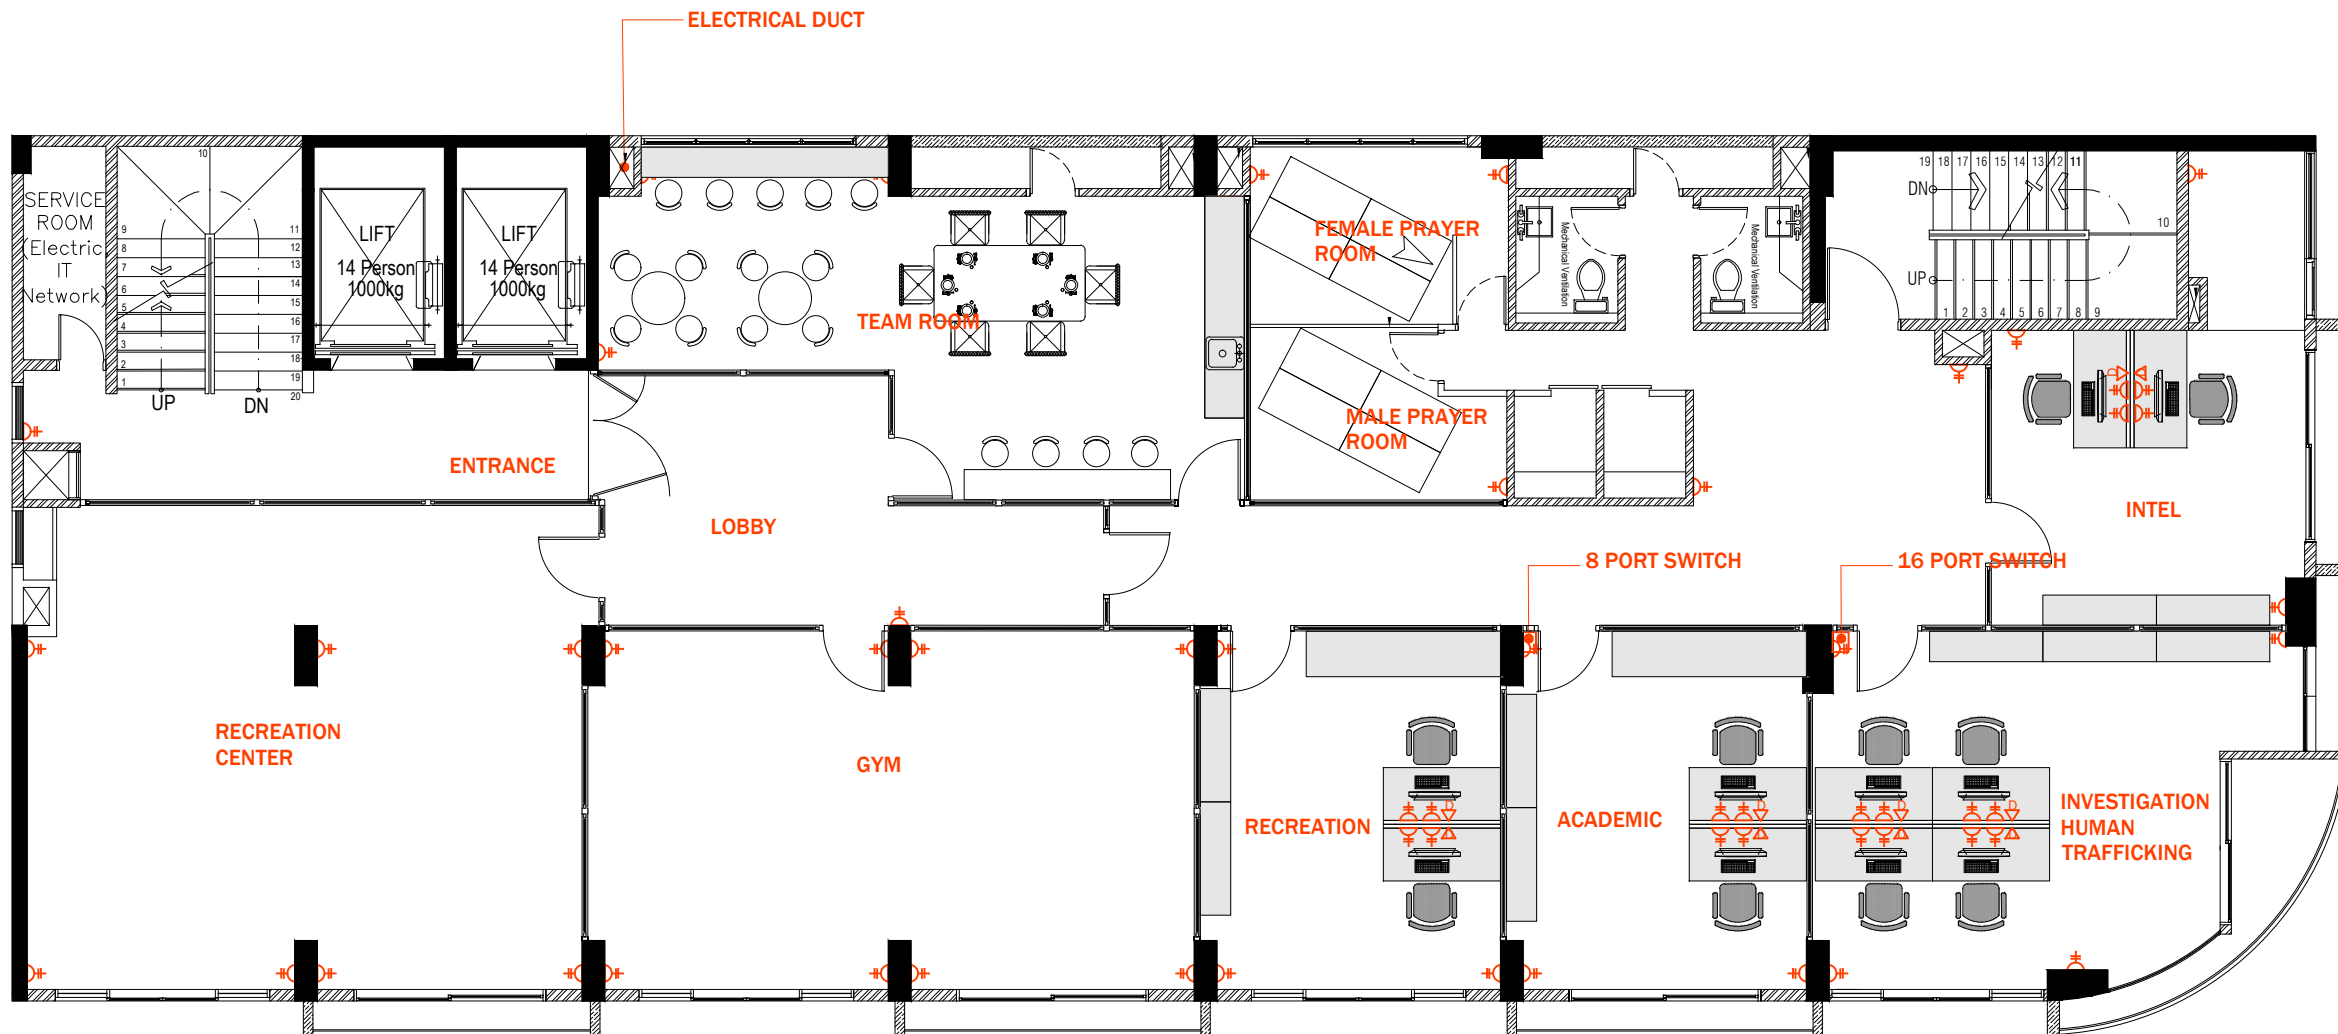

10TH FLOOR ELECTRICAL LAYOUT

SCALE 1:100



ELECTRICAL POWER AND LIGHTING LEGEND

SYMBOL	DESCRIPTION
	15AMP X 1 GANG POWER SOCKET
	13AMP X 1 GANG POWER SOCKET
	13AMP X 2 GANG POWER SOCKET
	15AMP X 1 GANG POWER SOCKET @ CEILING LVL
	SINGLE PHASE WITH ISOLATOR GANG POWER SOCKET
	3 PHASE WITH ISOLATOR GANG POWER SOCKET
	IP65 WEATHER PROOF POWER SOCKET
	DATA SOCKET (RJ45)
	SHAVER SOCKET
	TELEPHONE SOCKET (RJ11)
	WIFI AMPLIFIER REPEATER
	TV SOCKET

IMPORTANT:

- ALL GIVEN HEIGHTS ARE FROM FINISHED FLOOR LEVEL
- ALL SWITCHES AT 1.2M HEIGHT ABOVE FINISHED FLOOR LEVEL EXCEPT WHERE SPECIFIED
- ALL SOCKETS AT 0.3M HEIGHT ABOVE FINISHED FLOOR LEVEL EXCEPT WHERE SPECIFIED
- UNLESS SPECIFIED OTHERWISE ALL LIGHT SWITCHES AND FAN DIMMERS AT BED SIDE ARE AT 0.75M FROM FLOOR FINISH LEVEL.
- SELECTED LIGHTING FIXTURE TO BE APPROVED BY CLIENT / ID
- SELECTED SWITCHES AND SOCKETS TO BE APPROVED BY CLIENT / ID
- UNLESS SPECIFIED OTHERWISE ALL LED LIGHTS ARE @ CILLING LVL
- ALL COCKETS FOR THE WORK STATION TO BE FIXED ON PER THE DESK

SHIYARCH

No.	Revision	Checked By	Date

Project Title:

IMMIGRATION OFFICE
(AT STAR CLOUD BUILDING)

Client:


MALDIVES IMMIGRATION

INTERIOR DESIGN

Drawing Title:
SITE PLAN

Architect:	Interior Designer:
SHIYA	-
Drawn By:	Checked By:
SHIYA	-
Paper:	Project No.:
A3	-
Date:	Scale:
FEBRUARY 2021	AS GIVEN
Drawing No.:	D-01 /01

Copyright: The concept and design in this drawing are the properties of shiyarch. unauthorized use of any kind or copying of whole or part of this drawing, concept or design or use on projects or sites other than specified on this drawing is prohibited and apply as terms and conditions under which the client is entitled to use the concept or design in this drawing.

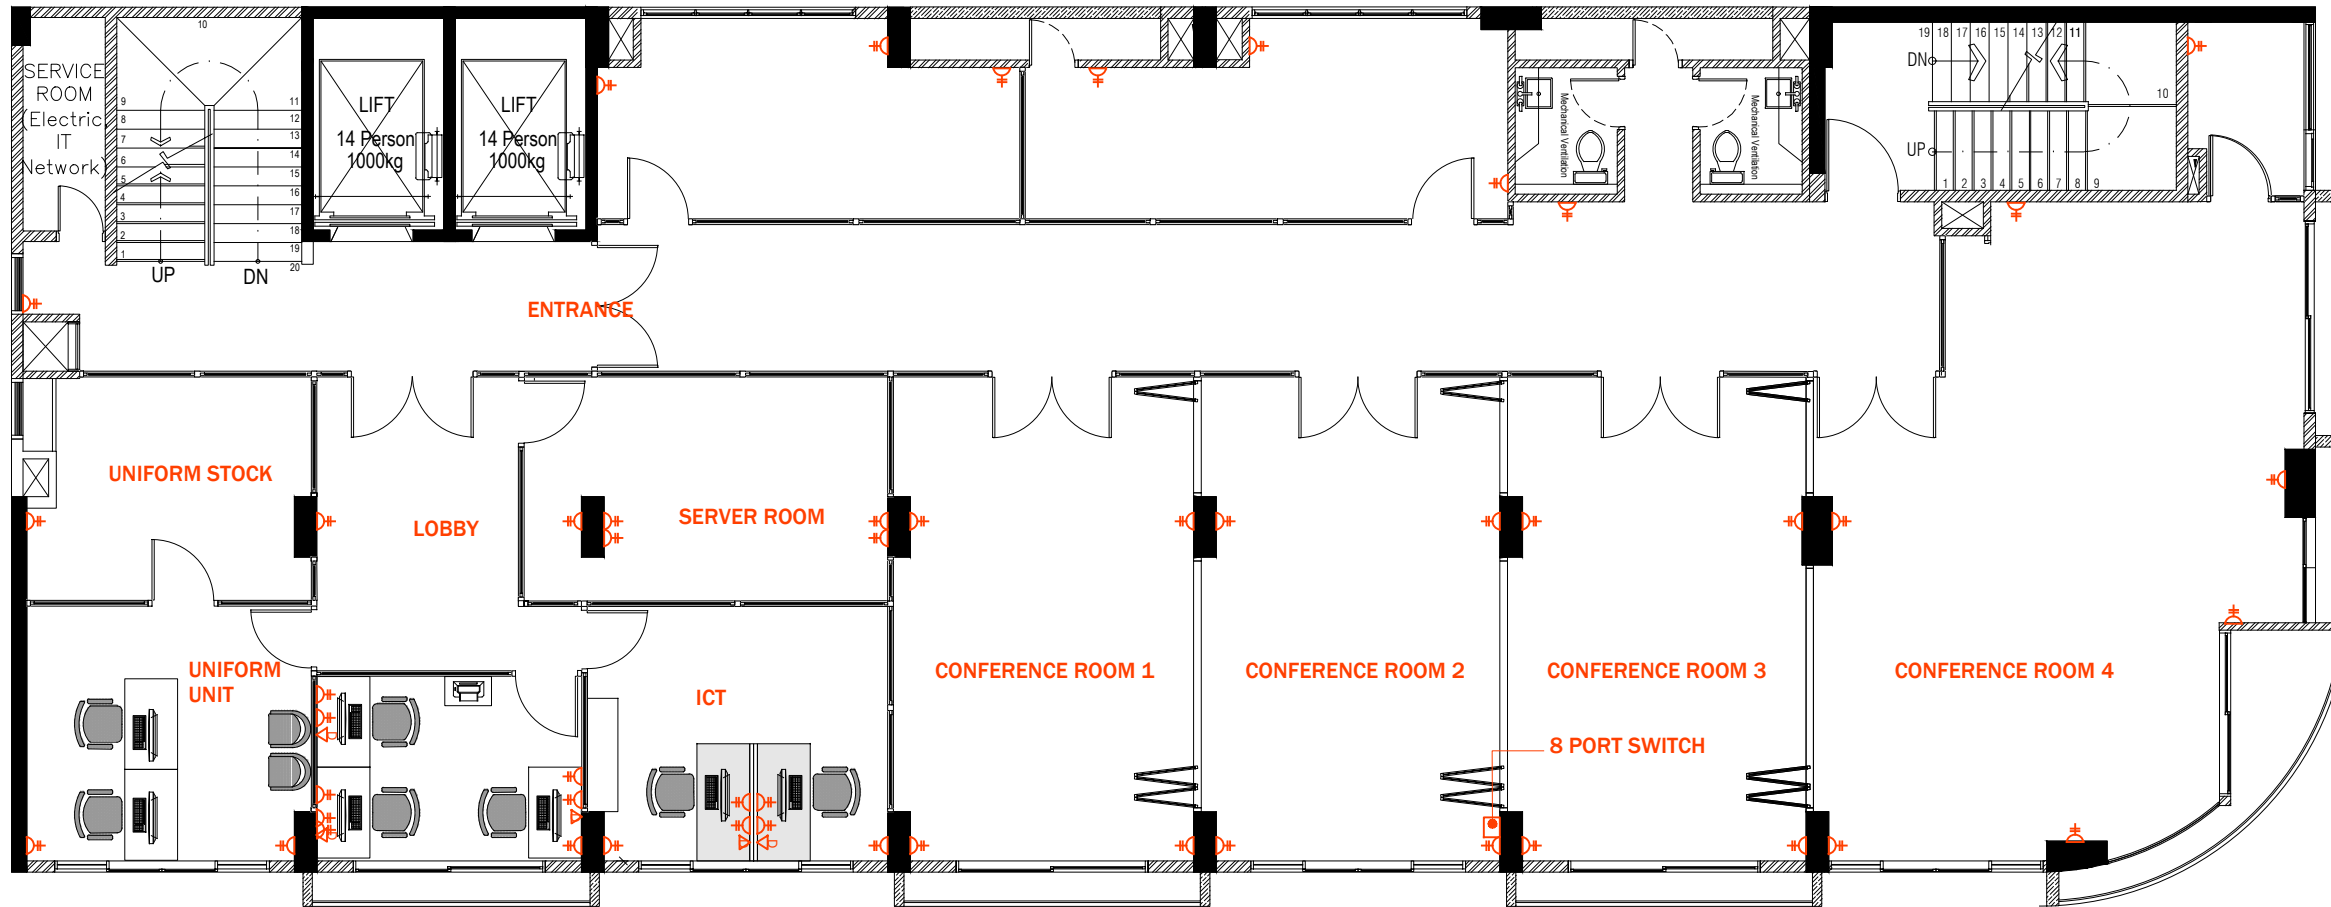

11TH FLOOR ELECTRICAL LAYOUT

SCALE 1:100



ELECTRICAL POWER AND LIGHTING LEGEND

SYMBOL	DESCRIPTION
	15AMP X 1 GANG POWER SOCKET
	13AMP X 1 GANG POWER SOCKET
	13AMP X 2 GANG POWER SOCKET
	15AMP X 1 GANG POWER SOCKET @ CEILING LVL
	SINGLE PHASE WITH ISOLATOR GANG POWER SOCKET
	3 PHASE WITH ISOLATOR GANG POWER SOCKET
	IP65 WEATHER PROOF POWER SOCKET
	DATA SOCKET (RJ45)
	SHAVER SOCKET
	TELEPHONE SOCKET (RJ11)
	WIFI AMPLIFIER REPEATER
	TV SOCKET

- IMPORTANT:**
- ALL GIVEN HEIGHTS ARE FROM FINISHED FLOOR LEVEL
 - ALL SWITCHES AT 1.2M HEIGHT ABOVE FINISHED FLOOR LEVEL EXCEPT WHERE SPECIFIED
 - ALL SOCKETS AT 0.3M HEIGHT ABOVE FINISHED FLOOR LEVEL EXCEPT WHERE SPECIFIED
 - UNLESS SPECIFIED OTHERWISE ALL LIGHT SWITCHES AND FAN DIMMERS AT BED SIDE ARE AT 0.75M FROM FLOOR FINISH LEVEL.
 - SELECTED LIGHTING FIXTURE TO BE APPROVED BY CLIENT / ID
 - SELECTED SWITCHES AND SOCKETS TO BE APPROVED BY CLIENT / ID
 - UNLESS SPECIFIED OTHERWISE ALL LED LIGHTS ARE @ CILLING LVL
 - ALL COCKETS FOR THE WORK STATION TO BE FIXED ON PER THE DESK

SHIYARCH

No.	Revision	Checked By	Date

Project Title:
**IMMIGRATION OFFICE
(AT STAR CLOUD BUILDING)**

Client:
MALDIVES IMMIGRATION

INTERIOR DESIGN

Drawing Title:
SITE PLAN

Architect:	Interior Designer:
SHIYA	
Drawn By:	Checked By:
SHIYA	
Paper:	Project No:
A3	
Date:	Scale:
FEBRUARY 2021	AS GIVEN
Drawing No:	D-01 /01

Copyright: The concept and design in this drawing are the properties of shiyarch. unauthorized use of any kind or copying of whole or part of this drawing, concept or design or use on projects or sites other than specified on this drawing is prohibited and apply as terms and conditions under which the client is entitled to use the concept or design in this drawing.