



STAR CLOUDS BUILDING ASSISTING ELECTRIC POINTS

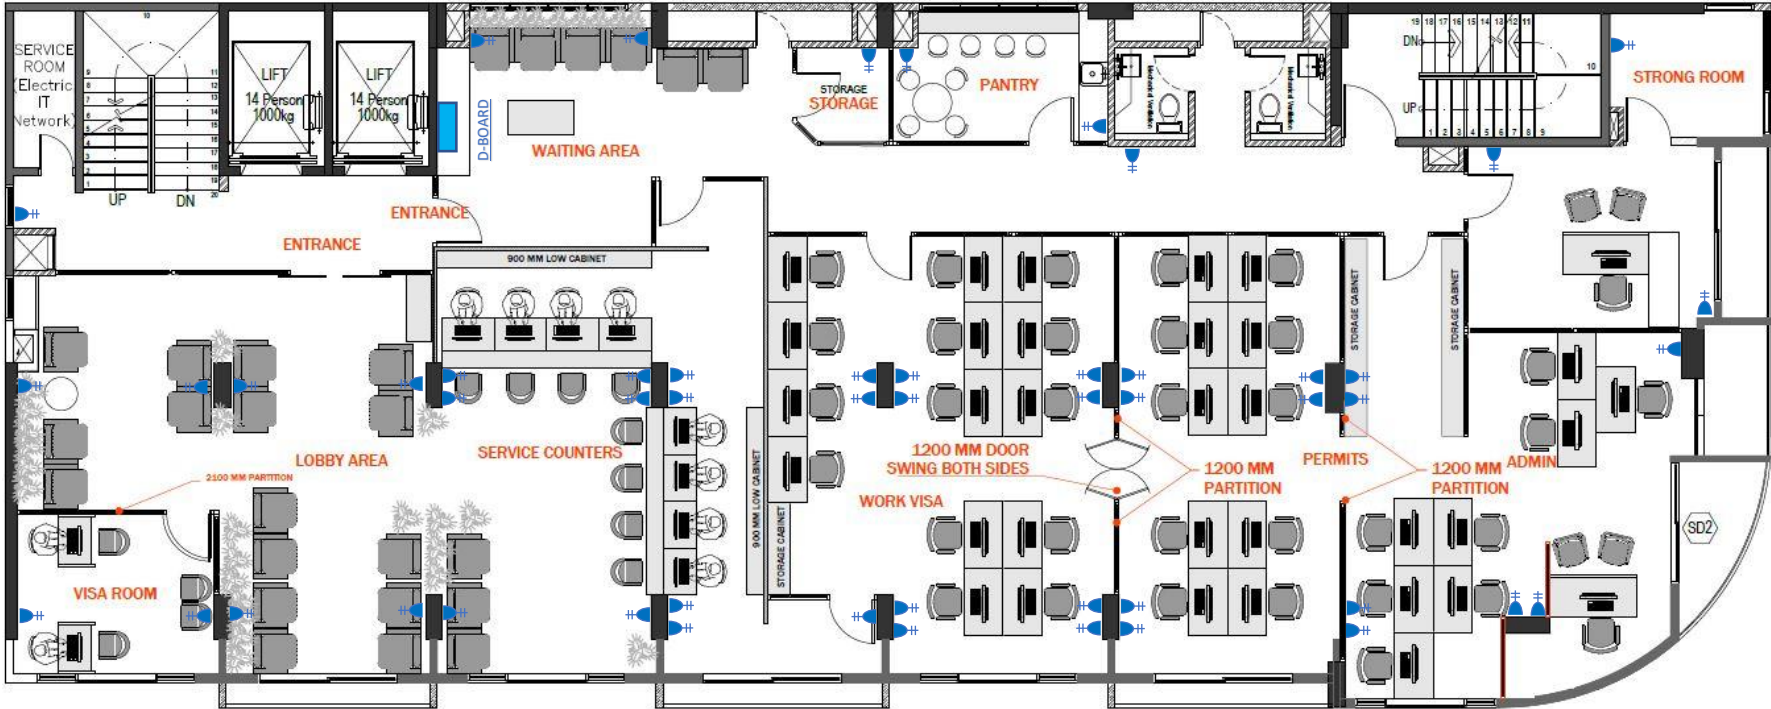

8TH FLOOR PLAN_OFFICES

SCALE 1:100




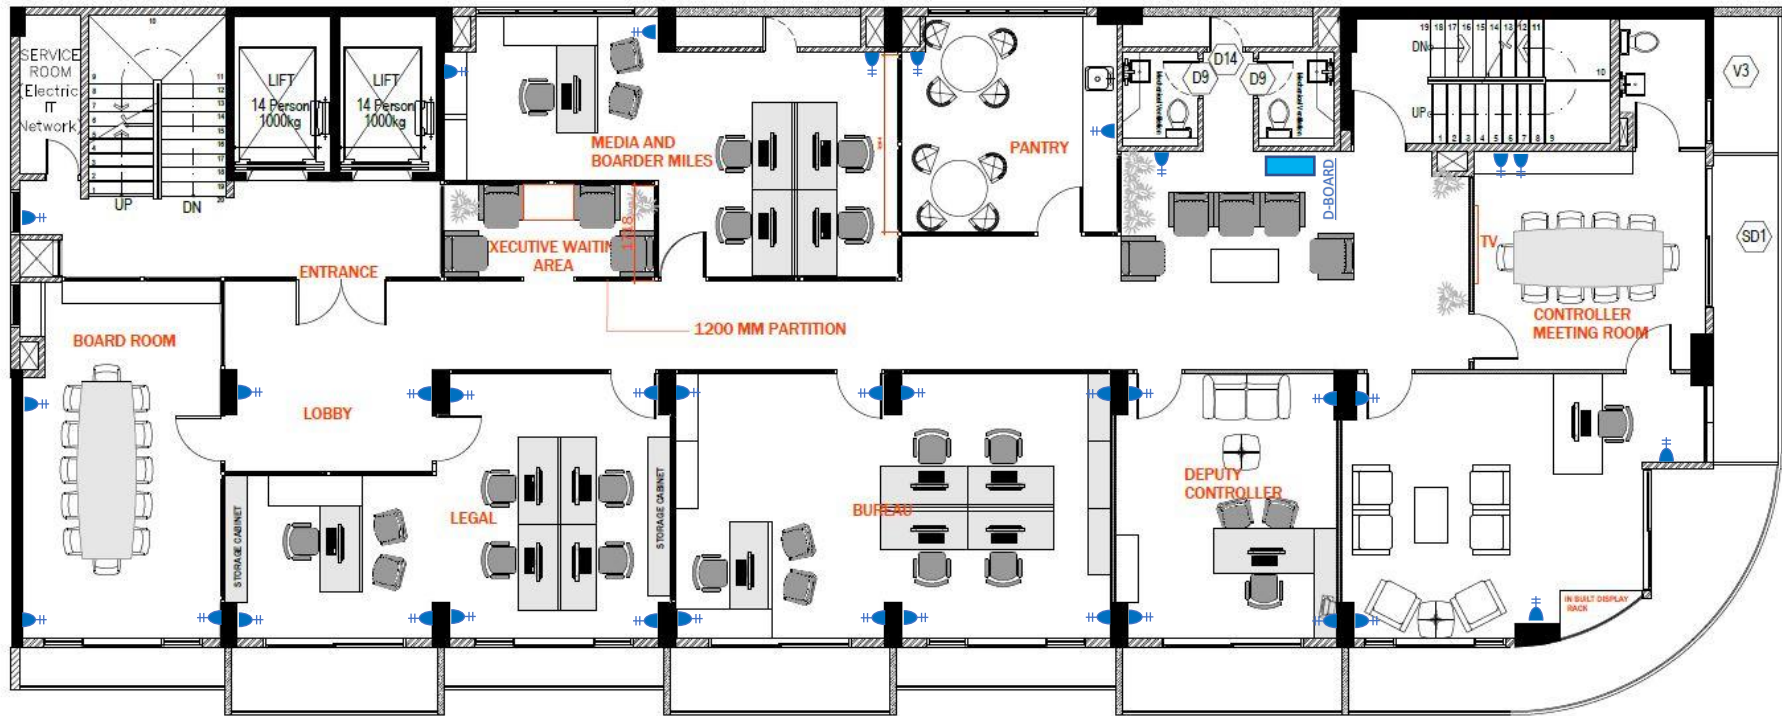

9TH FLOOR PLAN_OFFICES

SCALE 1:100




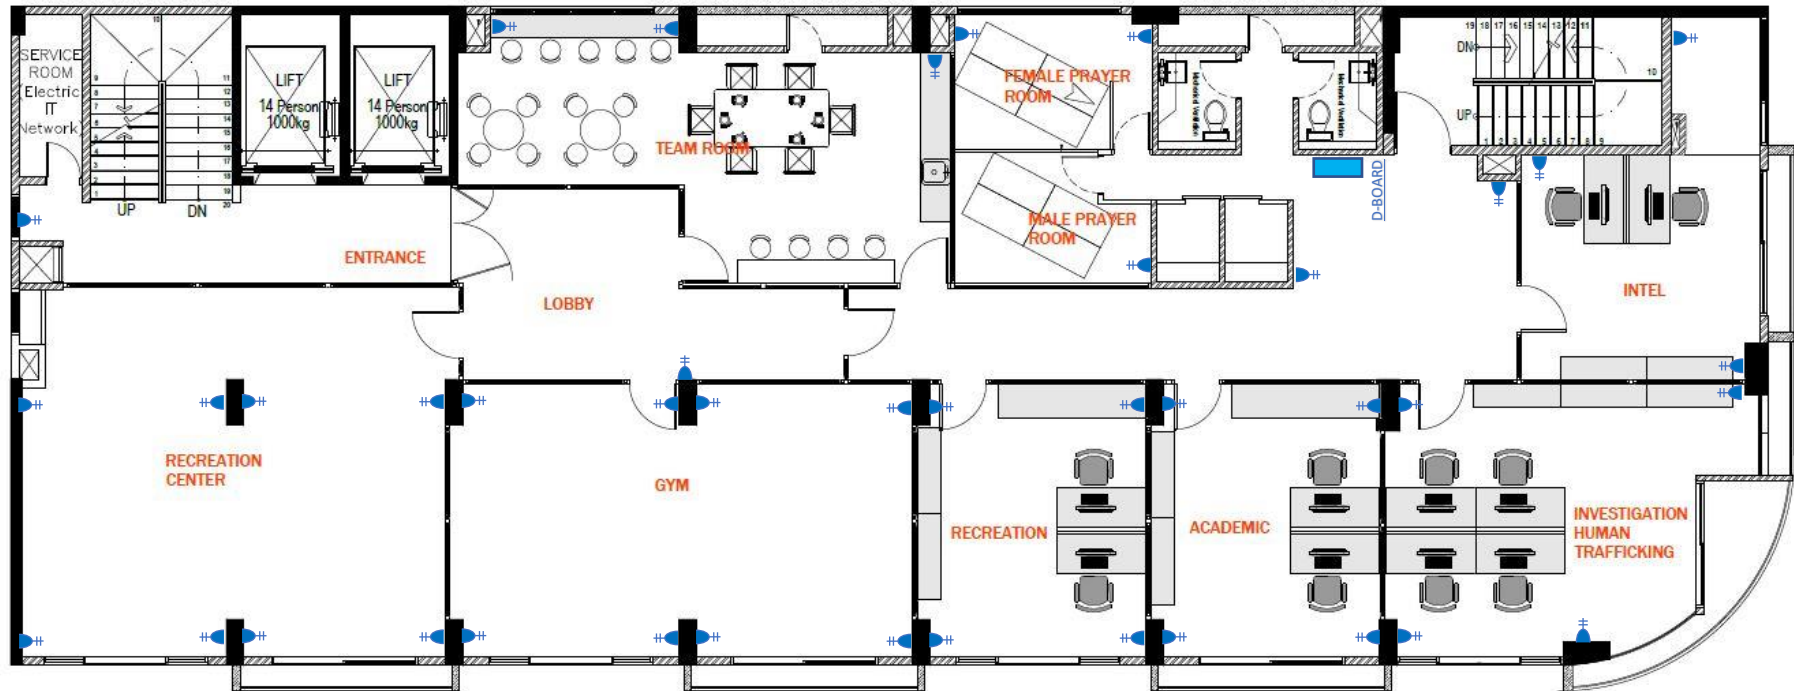

10TH FLOOR PLAN_OFFICES

SCALE 1:100



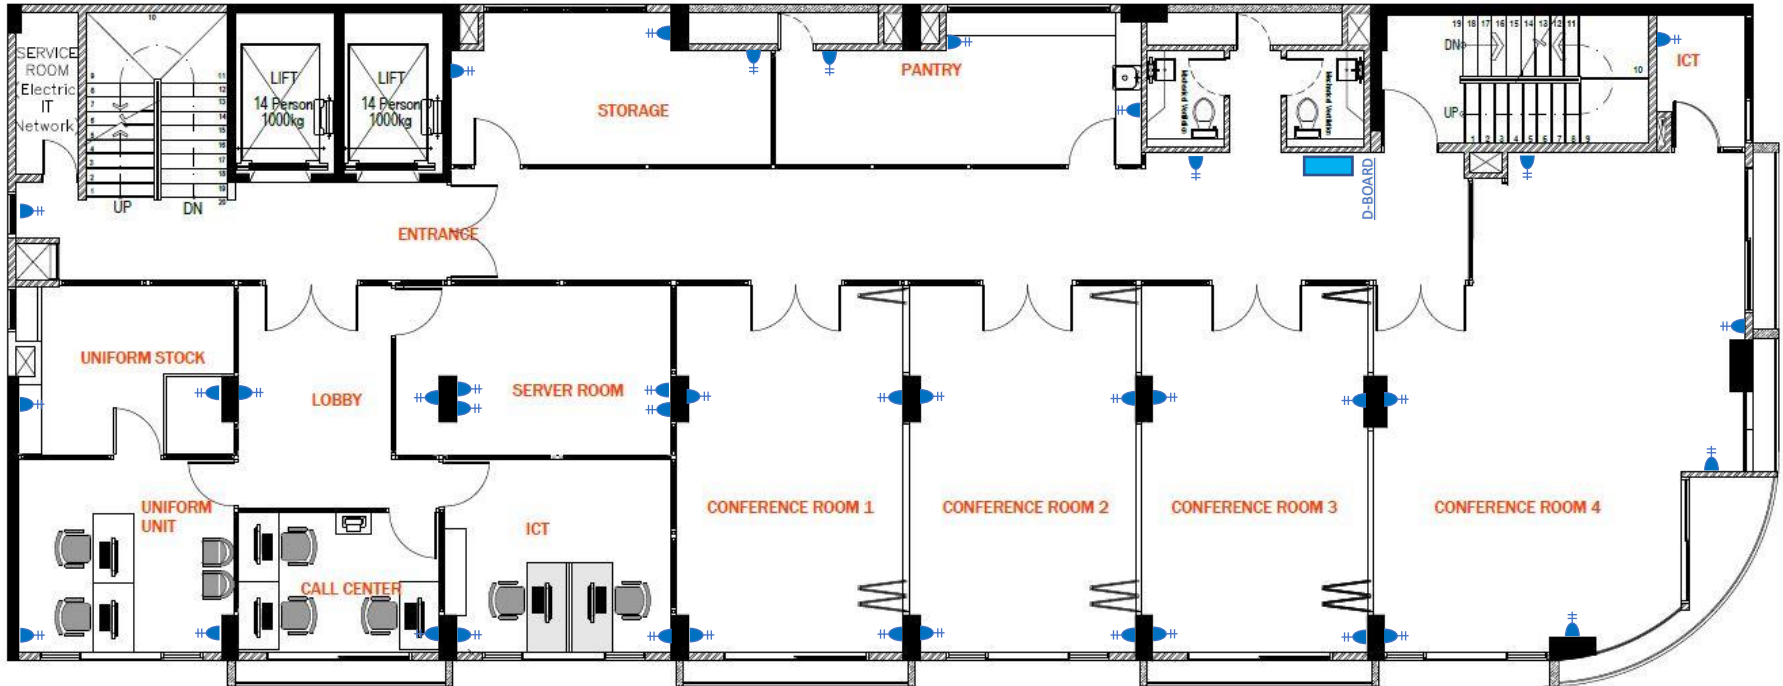

11TH FLOOR PLAN_OFFICES

SCALE 1:100

